



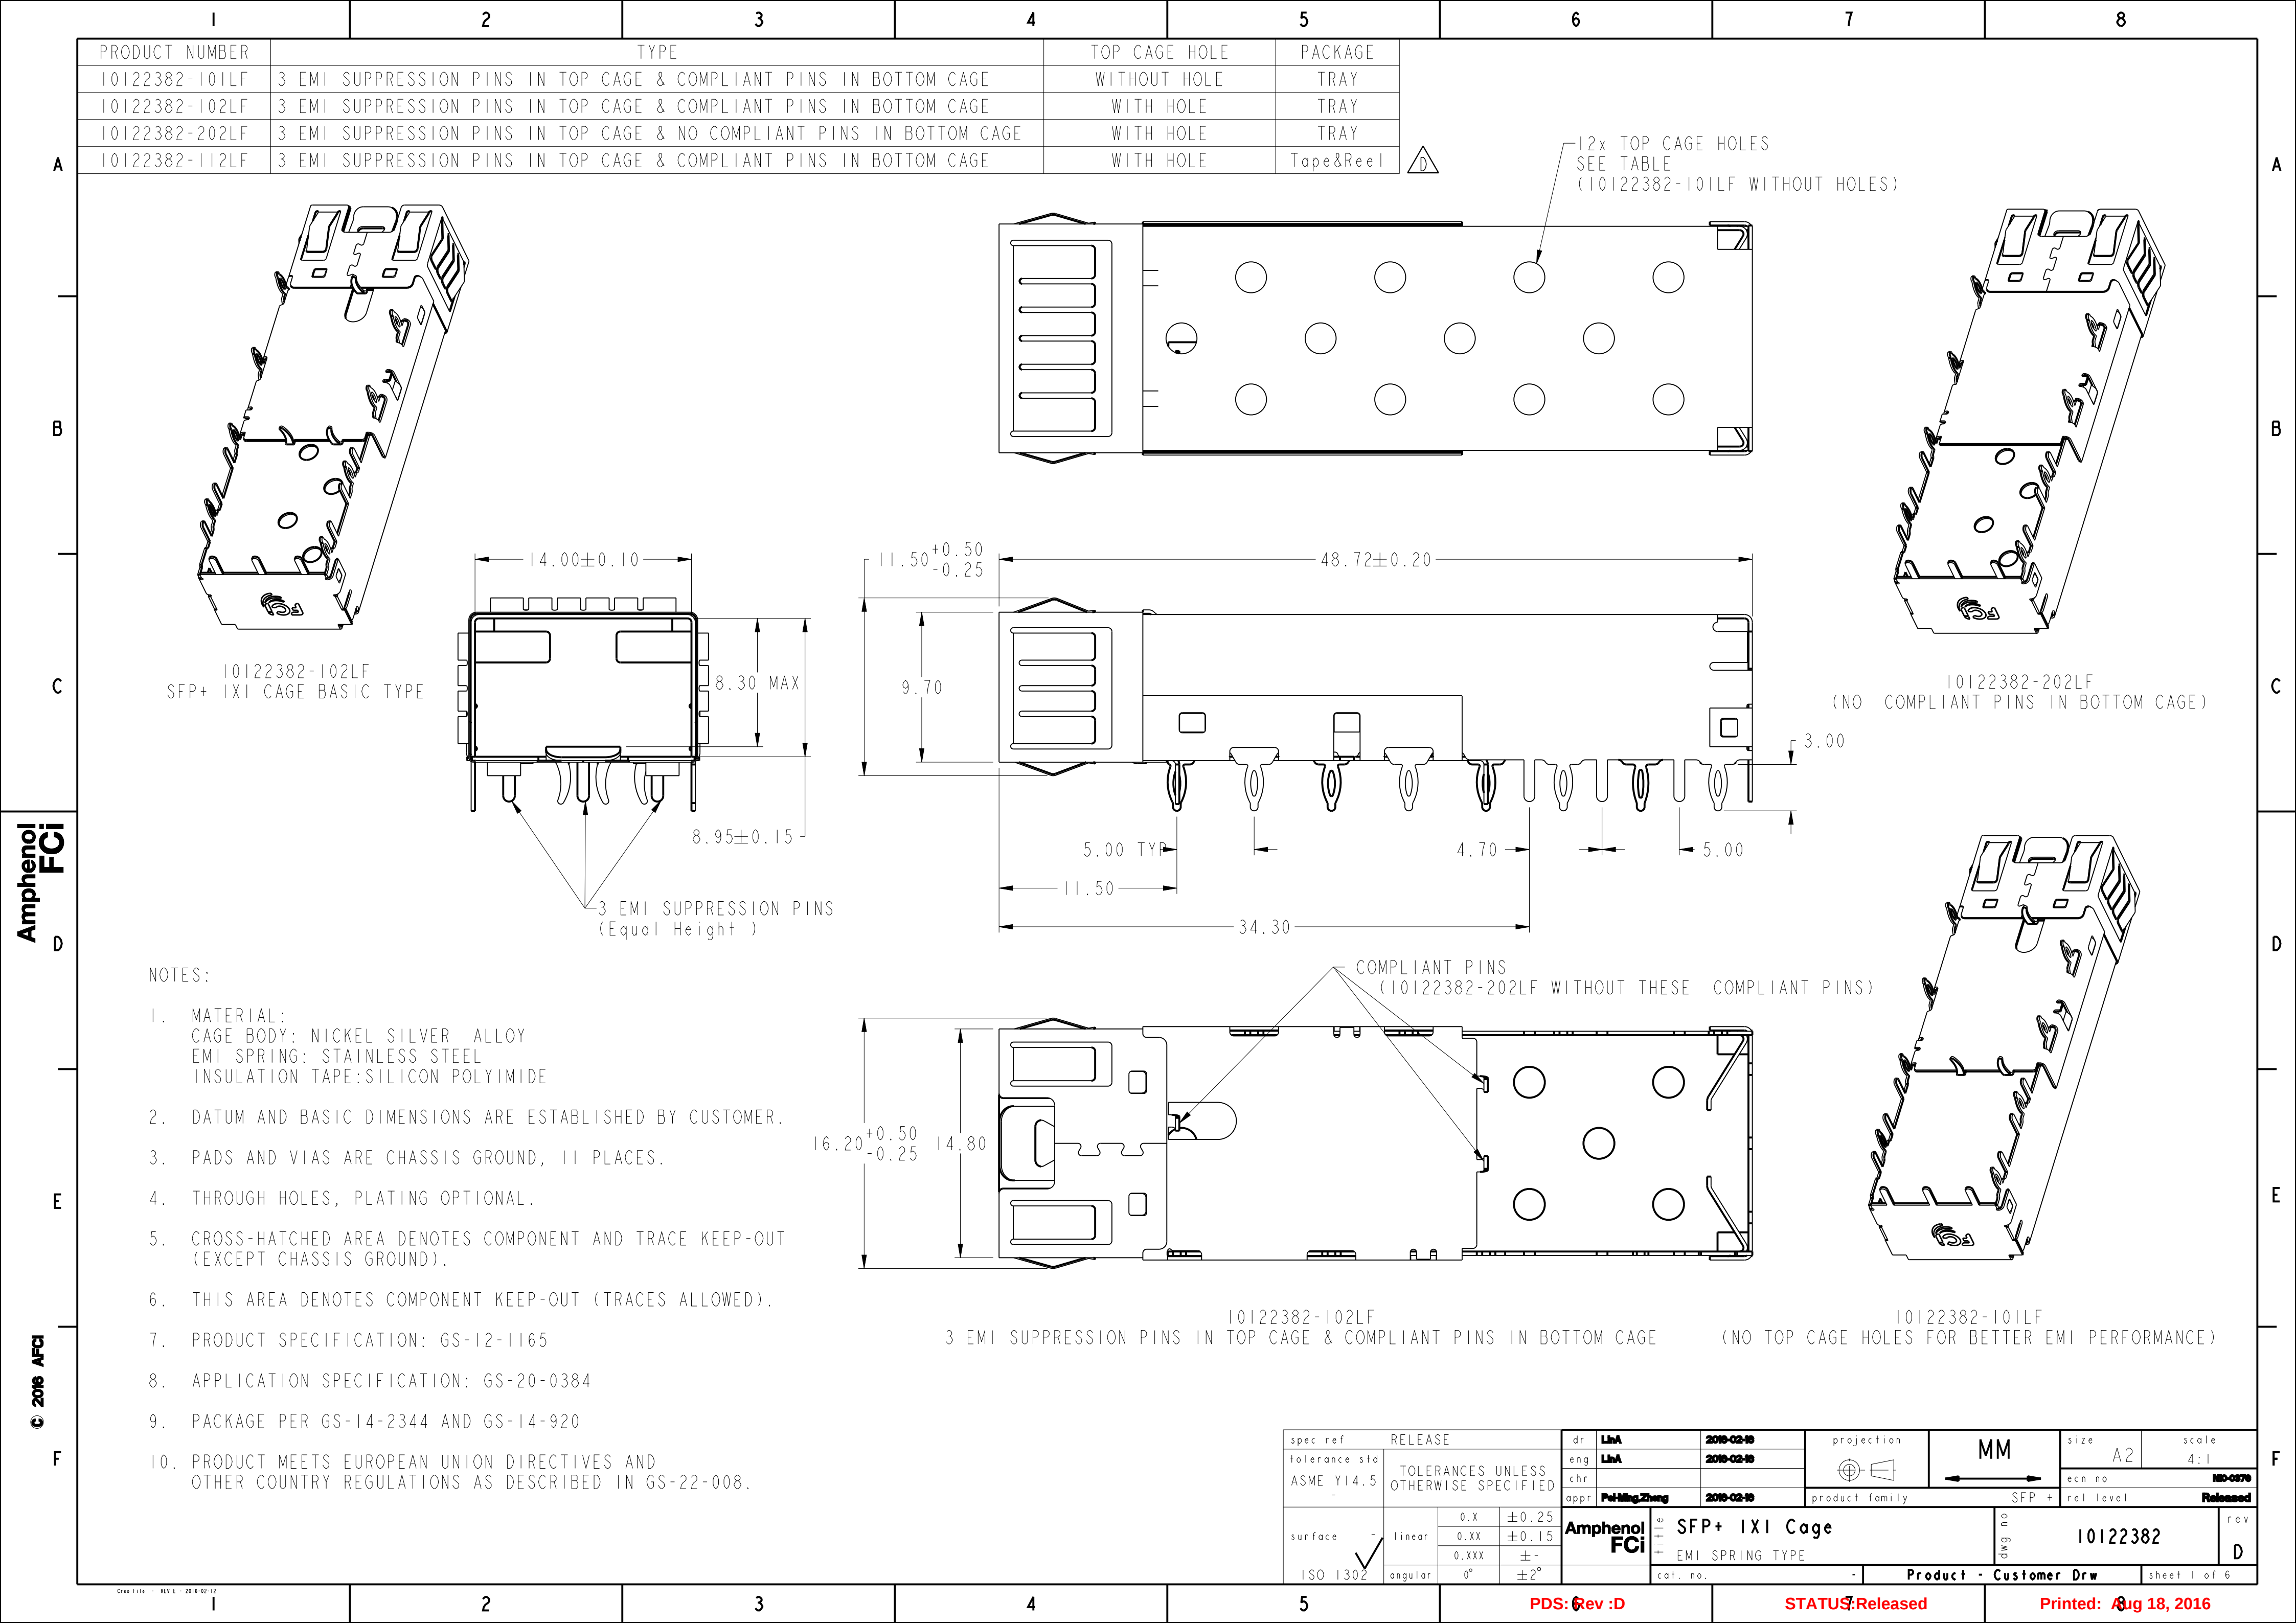

PRODUCT NUMBER	TYPE	TOP CAGE HOLE	PACKAGE
10122382-302LF	2 EMI SUPPRESSION PINS IN TOP CAGE & COMPLIANT PINS IN BOTTOM CAGE	WITH HOLE	TRAY
10122382-402LF	2 EMI SUPPRESSION PINS IN TOP CAGE & NO COMPLIANT PINS IN BOTTOM CAGE	WITH HOLE	TRAY

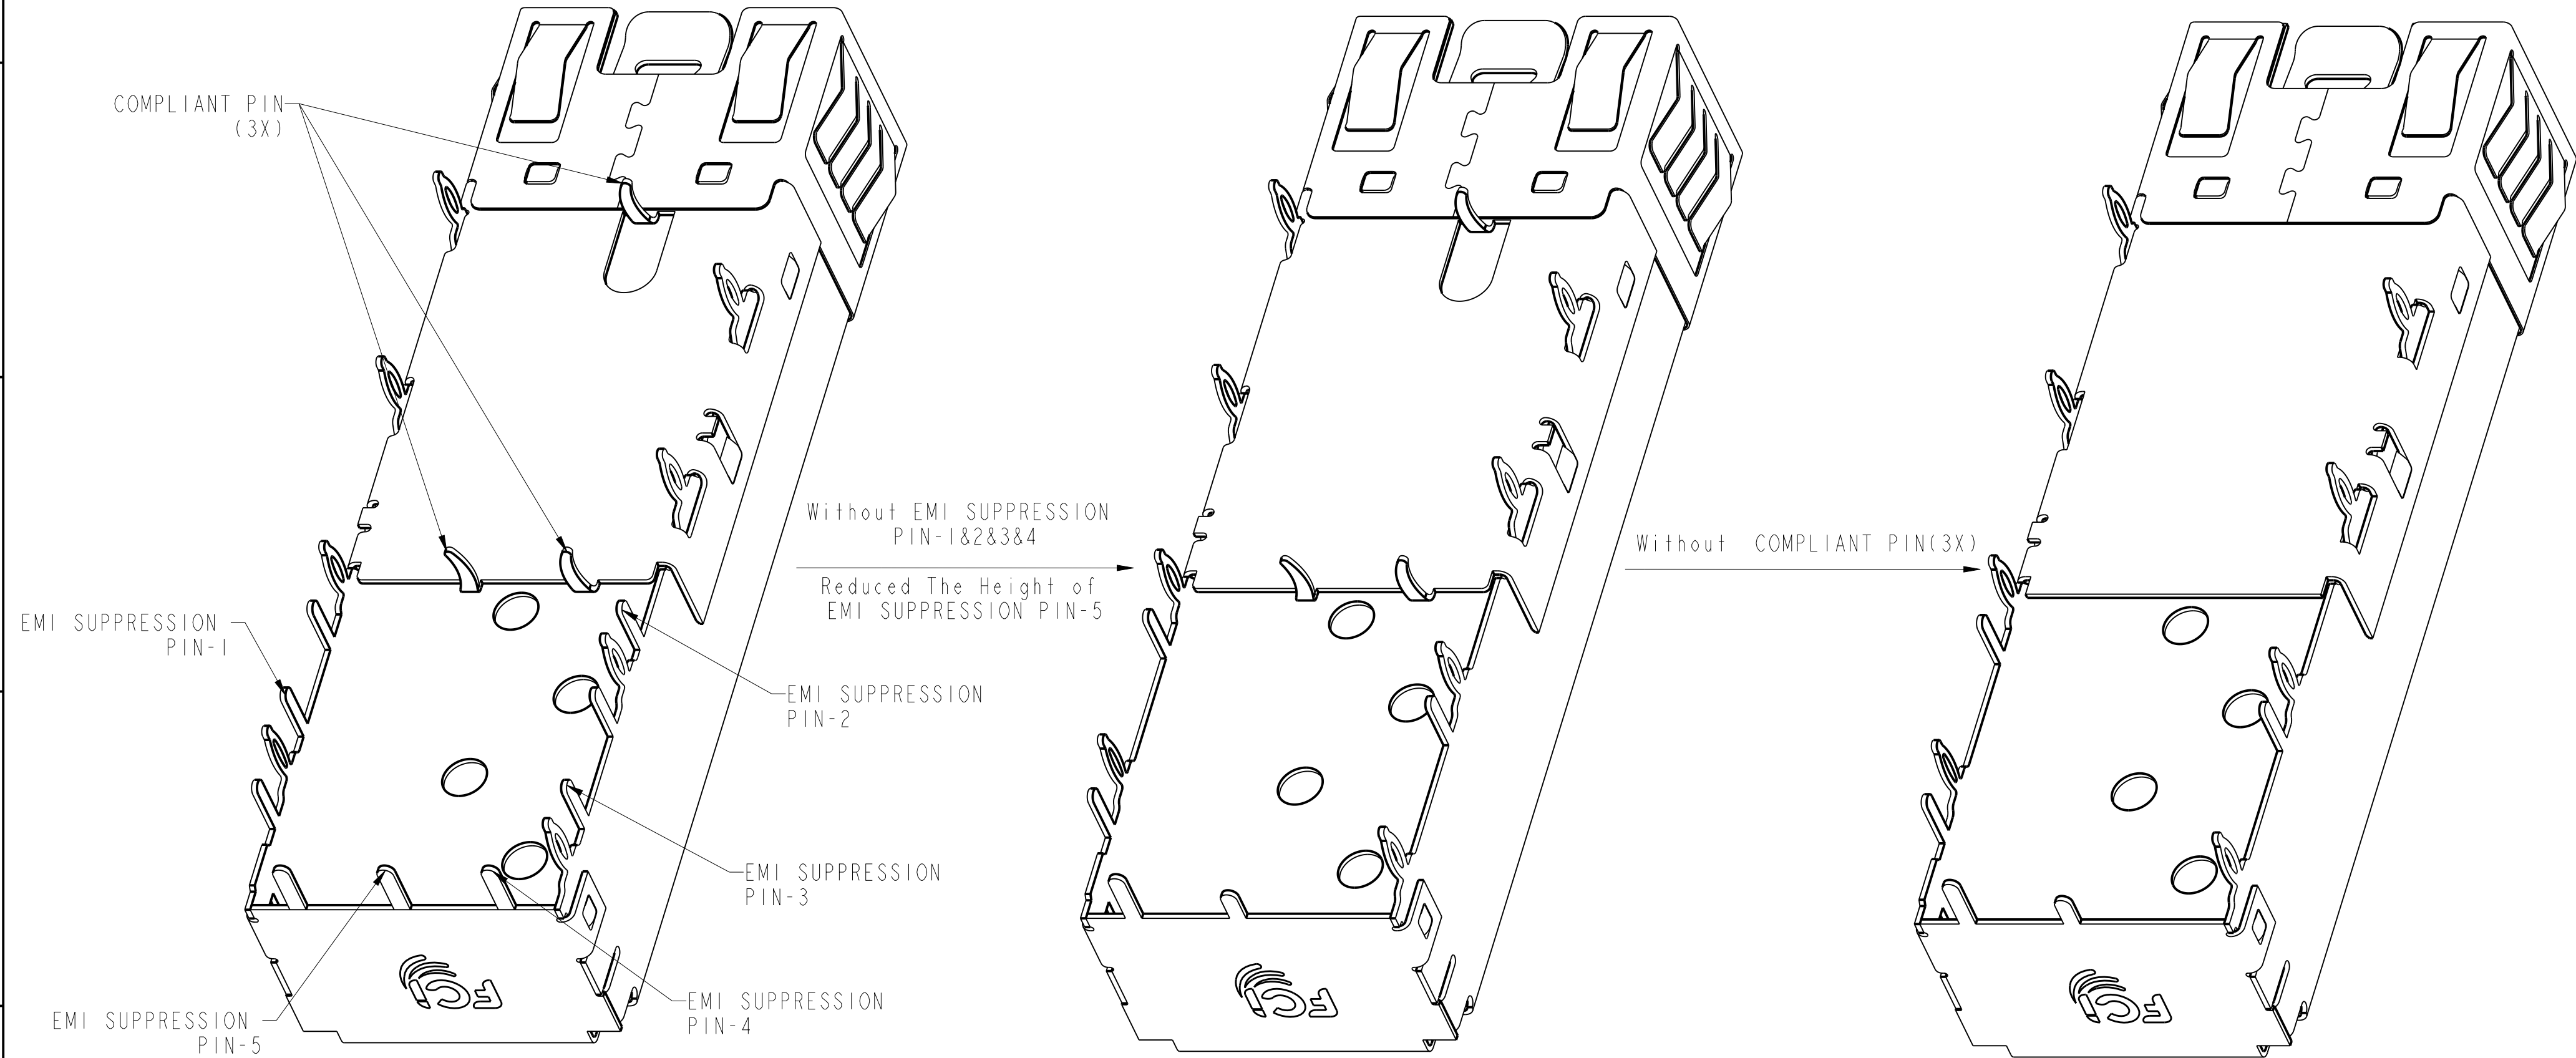

10122382-102LF

10122382-302LF

10122382-402LF


10122382-302LF/402LF WILL ALLOW FOR BELLY TO BELLY MOUNTING.

spec ref		RELEASE		dr		LhA	2016-02-16	projection				MM		size		A2	scale		5:1
tolerance std		TOLERANCES UNLESS OTHERWISE SPECIFIED		eng		LhA	2016-02-16			ecn no		100-0070		rel level		Released			
ASME Y14.5				chr															
				appr		Pei-Ming Zhang	2016-02-16	product family		SFP +									
surface		linear	0.X	±0.25	Amphenol FCI		title		SFP+ IXI Cage		dwg no		10122382		rev		D		
			0.XX	±0.15															
			0.XXX	± -															
ISO 1302		angular	0°	±2°			cat. no.		-		Product - Customer Drw		sheet 2 of 6						


PDS: Rev :D

STATUS:Released


Printed: Aug 18, 2016

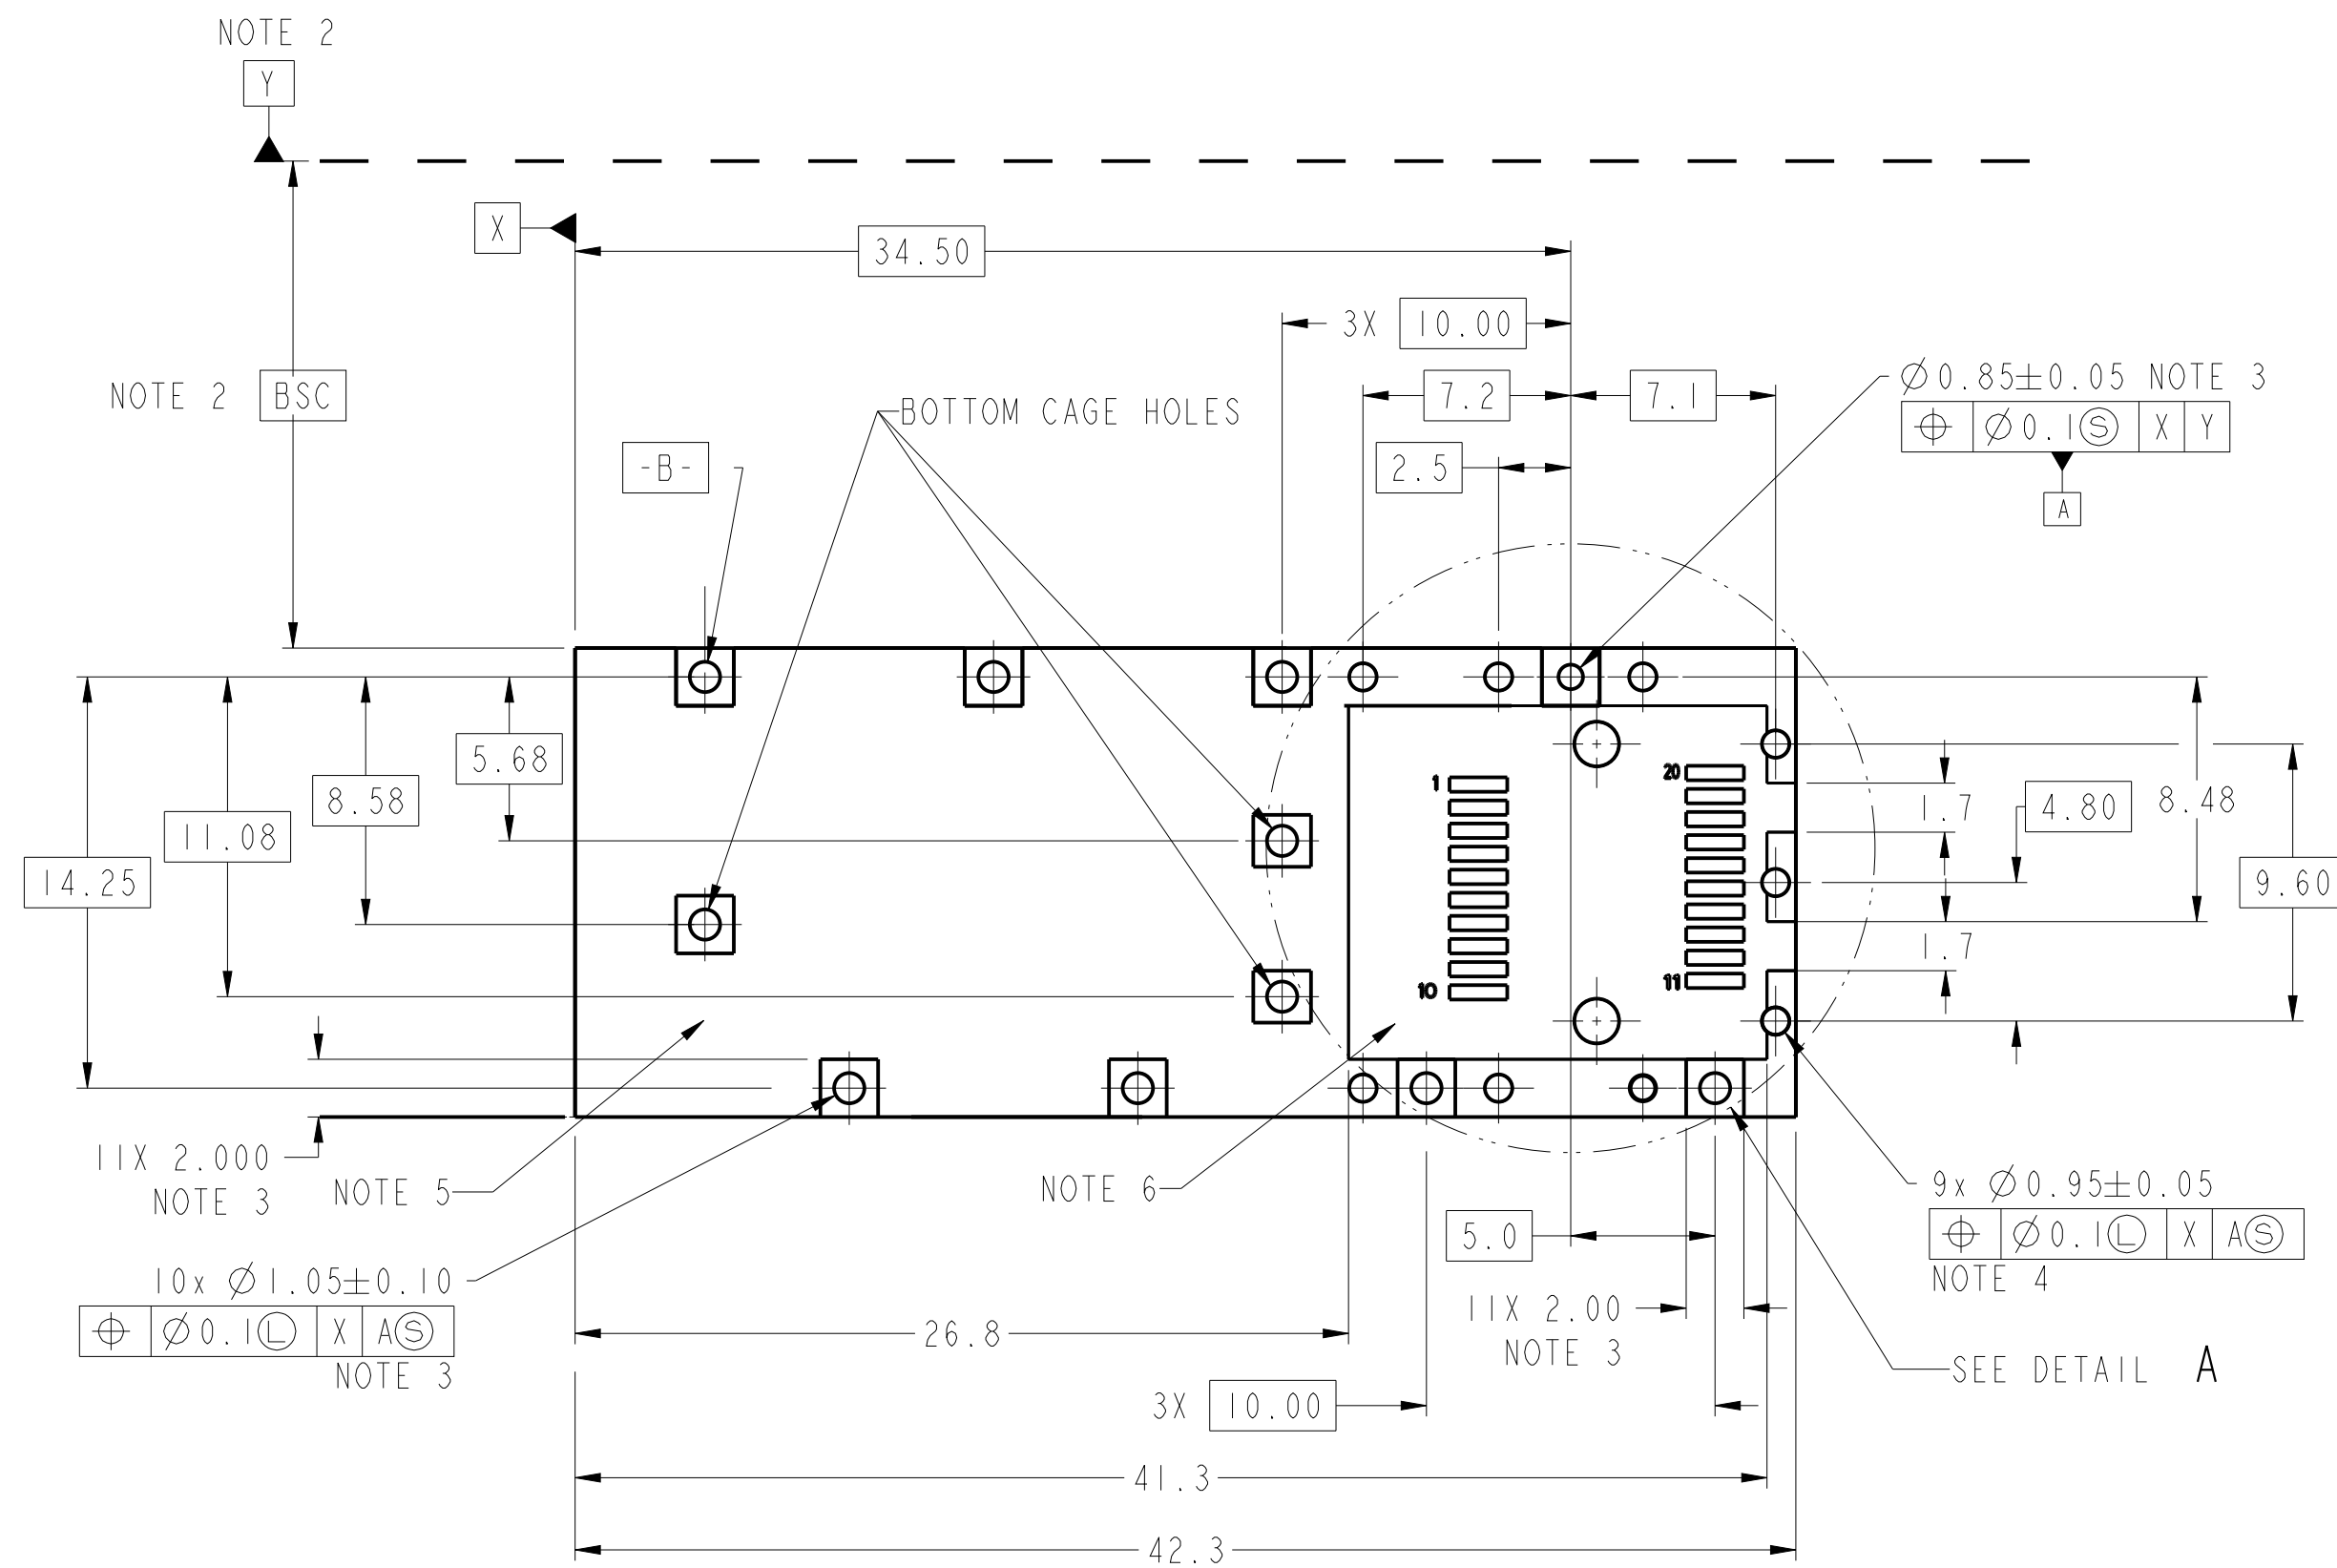

10122382-101LF/102LF/302LF/502LF
HOST BOARD MECHANICAL LAYOUT
SINGLE SIDED APPLICATIONS

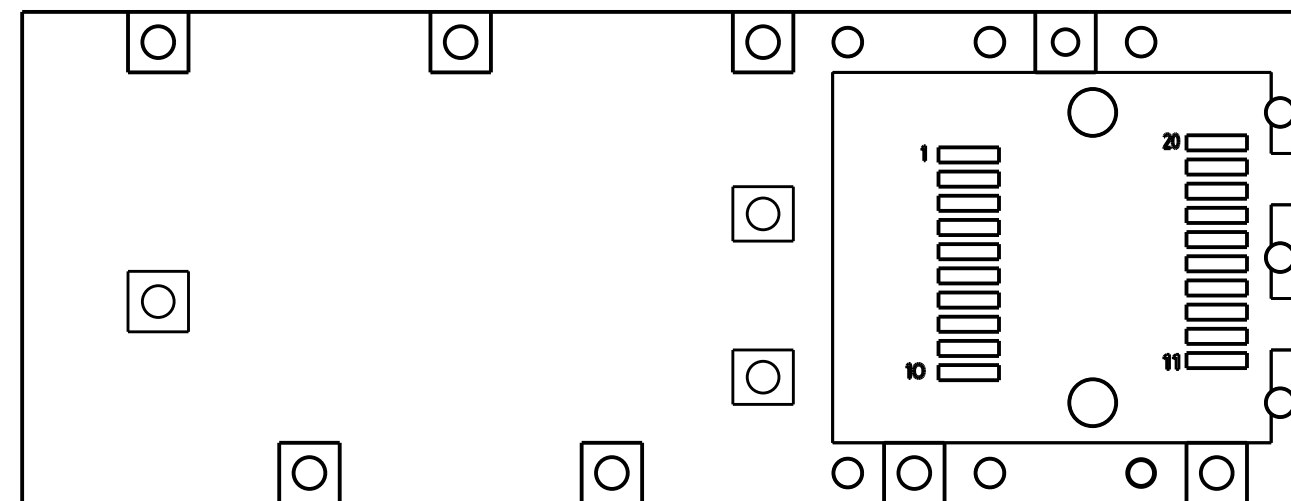

10122382-202LF
HOST BOARD MECHANICAL LAYOUT
SINGLE SIDED APPLICATIONS
(ONLY WITHOUT BOTTOM CAGE HOLES)

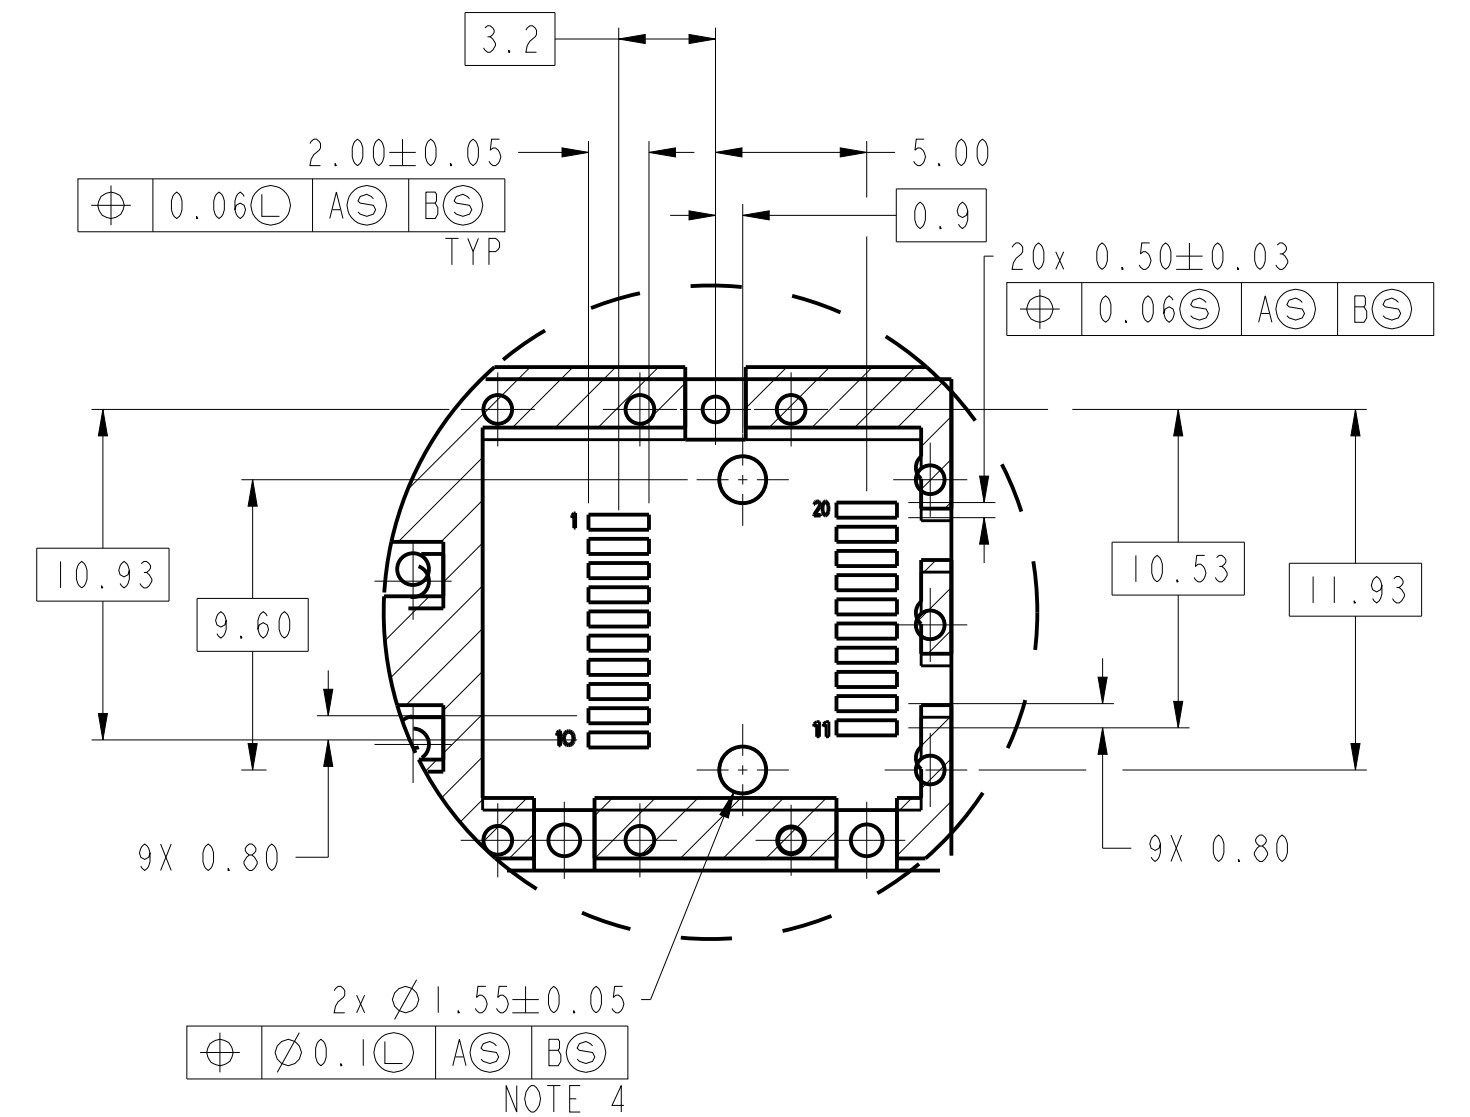

DETAIL A: HOST CONNECTOR LAYOUT
SCALE 4:1

NOTE:
SEE SHEET 4 FOR
HOST CONNECTOR LAYOUT

spec ref	RELEASE	dr	LhA	2016-02-18	projection	MM	size	A2	scale	4:1
tolerance std	ASME Y14.5	eng	LhA	2016-02-18	chr		ecn no	MD-0070	rel level	Released
surface	ISO 1302	appr	Pei-Ming Zhang	2016-02-18	product family		cat. no.	10122382	rev	D
TOLERANCES UNLESS OTHERWISE SPECIFIED		Amphenol FCI		SFP+ 1X1 Cage		EMI SPRING TYPE		Product - Customer Drw		sheet 4 of 6
linear		0.X		±0.25		0.XX		±0.15		
angular		0°		±2°						





10122382-302LF
HOST BOARD MECHANICAL LAYOUT
BELLY TO BELLY APPLICATIONS





10122382-402LF
HOST BOARD MECHANICAL LAYOUT
BELLY TO BELLY APPLICATIONS
(ONLY WITHOUT BOTTOM CAGE HOLES)


spec ref		RELEASE		dr		LinA		2010-02-10		projection				MM		size		A2		scale		1:1	
tolerance std		TOLERANCES UNLESS OTHERWISE SPECIFIED		eng		LinA		2010-02-10						ecn no		MD-0570							
ASME Y14.5				chr												rel level		Released					
-				appr		PeiHing.Zhang		2010-02-10		product family		-											
surface		linear		0.X		±0.25		Amphenol FCI		title		SFP+ 1X1 Cage		dwg no		10122382		rev					
																				0.XX		±0.15	
																				0.XXX		±	
ISO 1302		angular		0°		±2°				cat. no.		-		Product - Customer Drw		sheet 5 of 6		D					

BEZEL AND BOARD POSITION DIMENSIONS FOR SINGLE SIDE MOUNTING
(EMI SPRING FINGER)

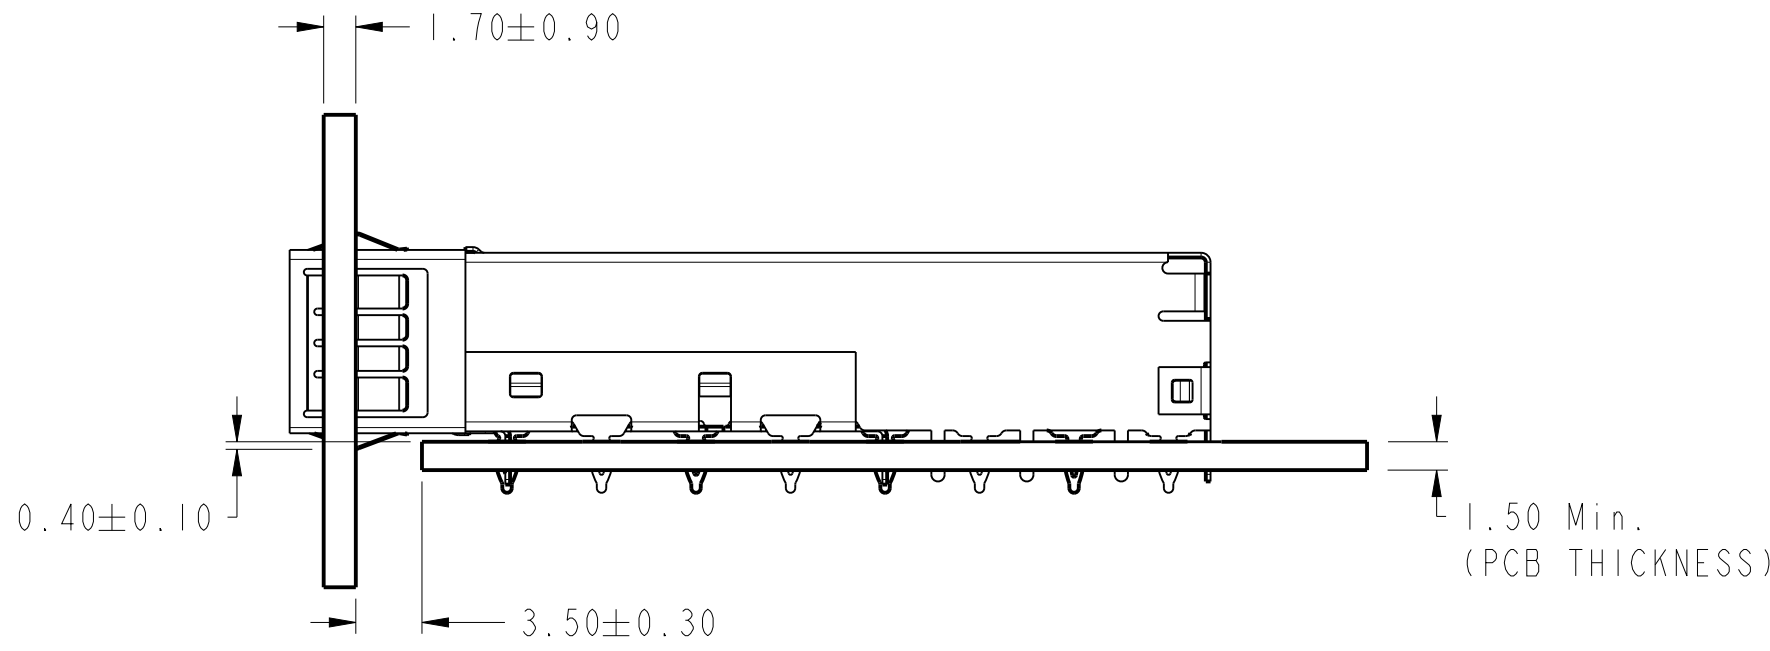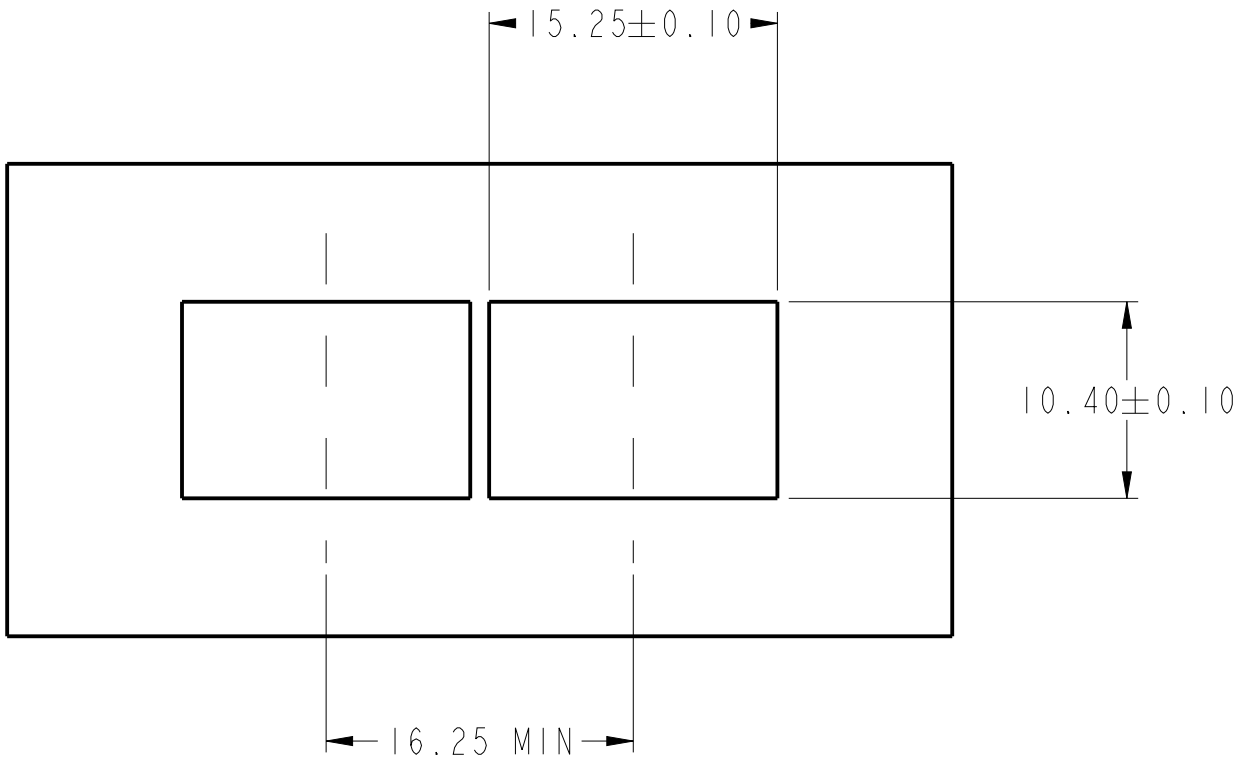

 10122382-302LF/402LF
BEZEL AND BOARD POSITION DIMENSIONS FOR BELLY TO BELLY MOUNTING
(EMI SPRING FINGER)

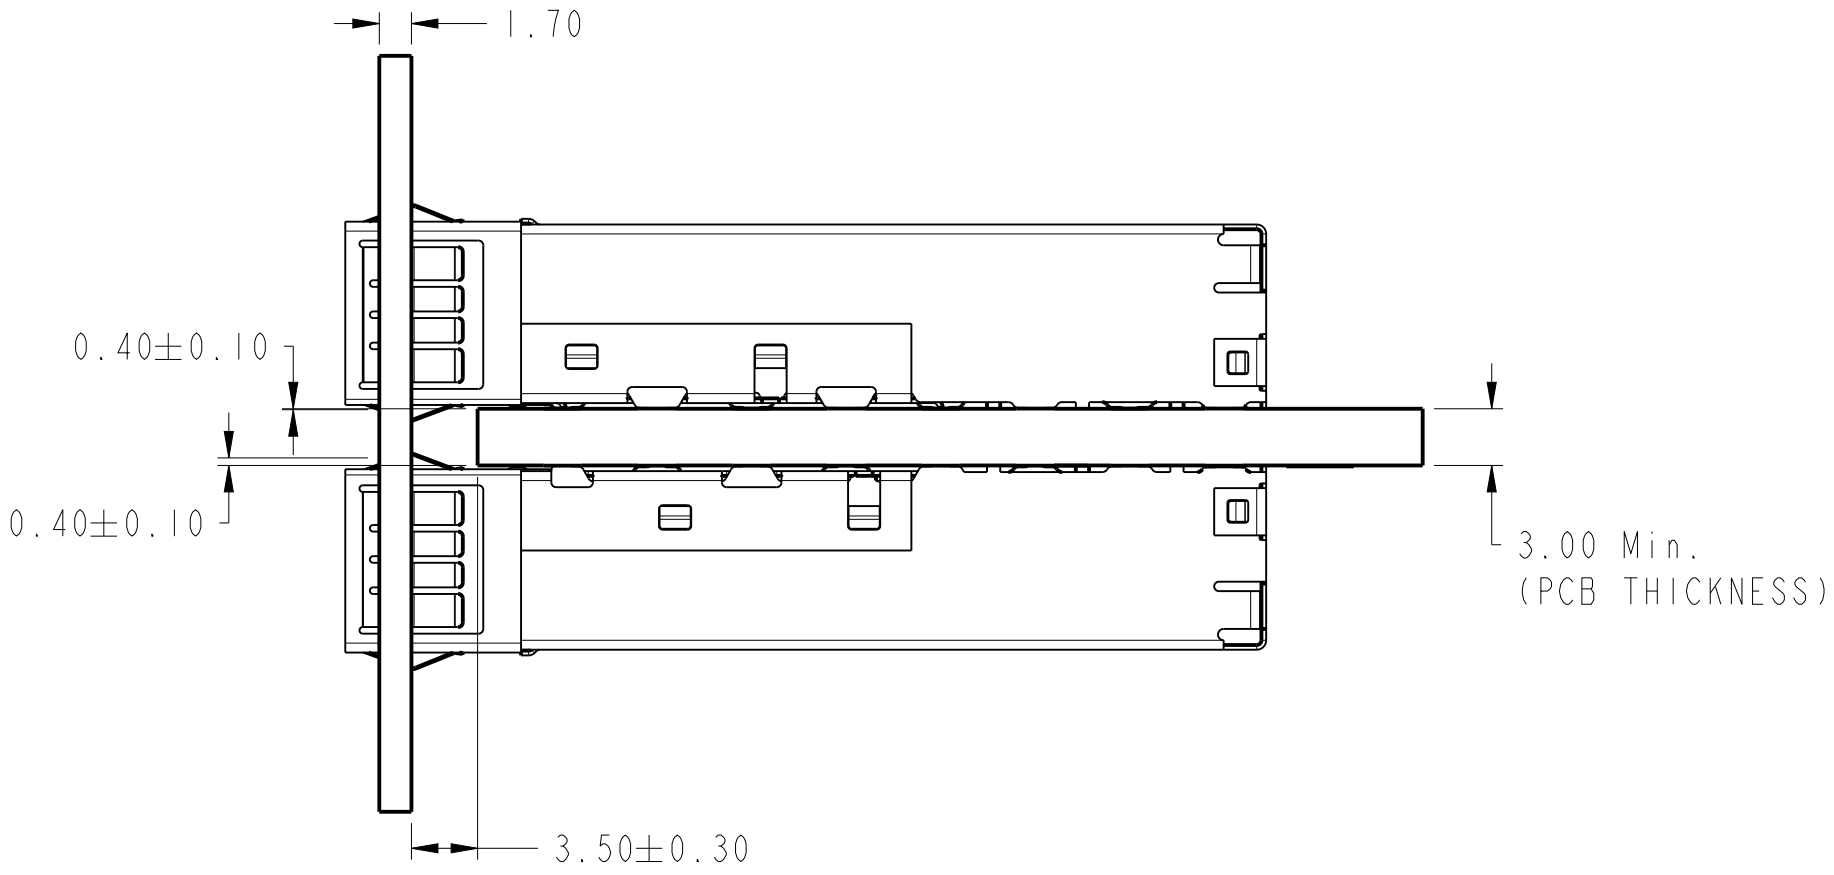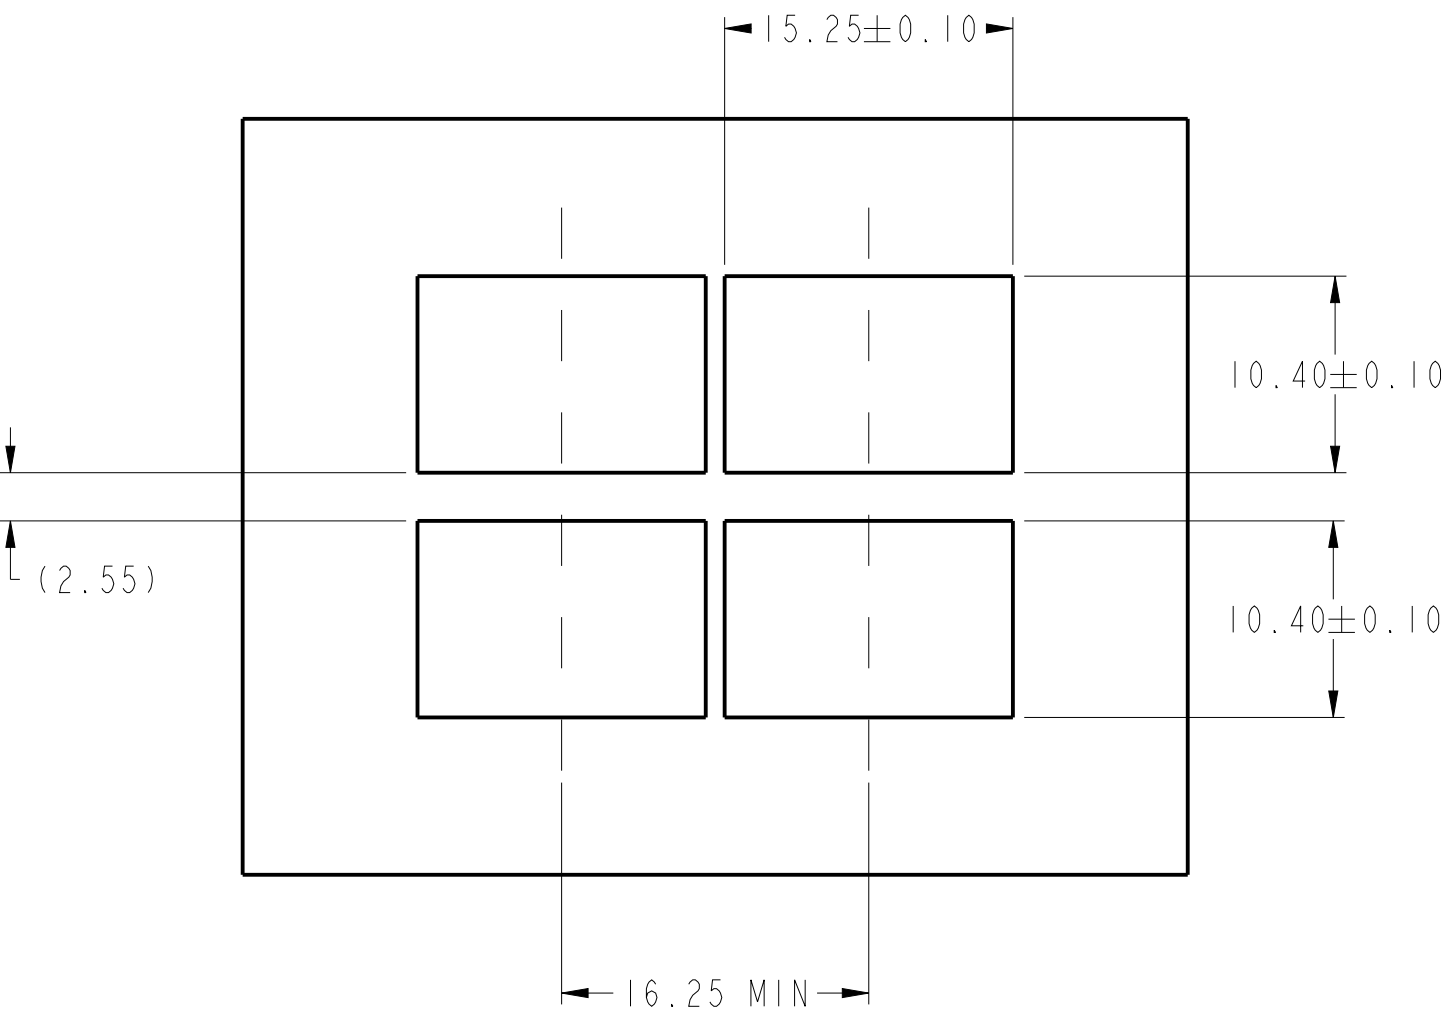

spec ref	RELEASE			dr	LhA	2016-02-16	projection		MM		size	A2	scale	1:1
tolerance std	TOLERANCES UNLESS OTHERWISE SPECIFIED			eng	LhA	2016-02-16					ecn no	ND-0070		
ASME Y14.5				chr			product family	SFP +	rel level	Released				
-				appr	Pei-Ming.Zhang	2016-02-16								
surface	linear	0.X	±0.25	Amphenol FCI	title	SFP+ IXI Cage			dwg no	10122382			rev	D
		0.XX	±0.15											
		0.XXX	±-											
ISO 1302	angular	0°	±2°		cat. no.	-	Product - Customer Drw			sheet 6 of 6				

Компания «Life Electronics» занимается поставками электронных компонентов импортного и отечественного производства от производителей и со складов крупных дистрибьюторов Европы, Америки и Азии.

С конца 2013 года компания активно расширяет линейку поставок компонентов по направлению коаксиальный кабель, кварцевые генераторы и конденсаторы (керамические, пленочные, электролитические), за счёт заключения дистрибьюторских договоров

Мы предлагаем:

- Конкурентоспособные цены и скидки постоянным клиентам.
- Специальные условия для постоянных клиентов.
- Подбор аналогов.
- Поставку компонентов в любых объемах, удовлетворяющих вашим потребностям.
- Приемлемые сроки поставки, возможна ускоренная поставка.
- Доставку товара в любую точку России и стран СНГ.
- Комплексную поставку.
- Работу по проектам и поставку образцов.
- Формирование склада под заказчика.
- Сертификаты соответствия на поставляемую продукцию (по желанию клиента).
- Тестирование поставляемой продукции.
- Поставку компонентов, требующих военную и космическую приемку.
- Входной контроль качества.
- Наличие сертификата ISO.

В составе нашей компании организован Конструкторский отдел, призванный помогать разработчикам, и инженерам.

Конструкторский отдел помогает осуществить:

- Регистрацию проекта у производителя компонентов.
- Техническую поддержку проекта.
- Защиту от снятия компонента с производства.
- Оценку стоимости проекта по компонентам.
- Изготовление тестовой платы монтаж и пусконаладочные работы.



Тел: +7 (812) 336 43 04 (многоканальный)

Email: org@lifeelectronics.ru

www.lifeelectronics.ru