


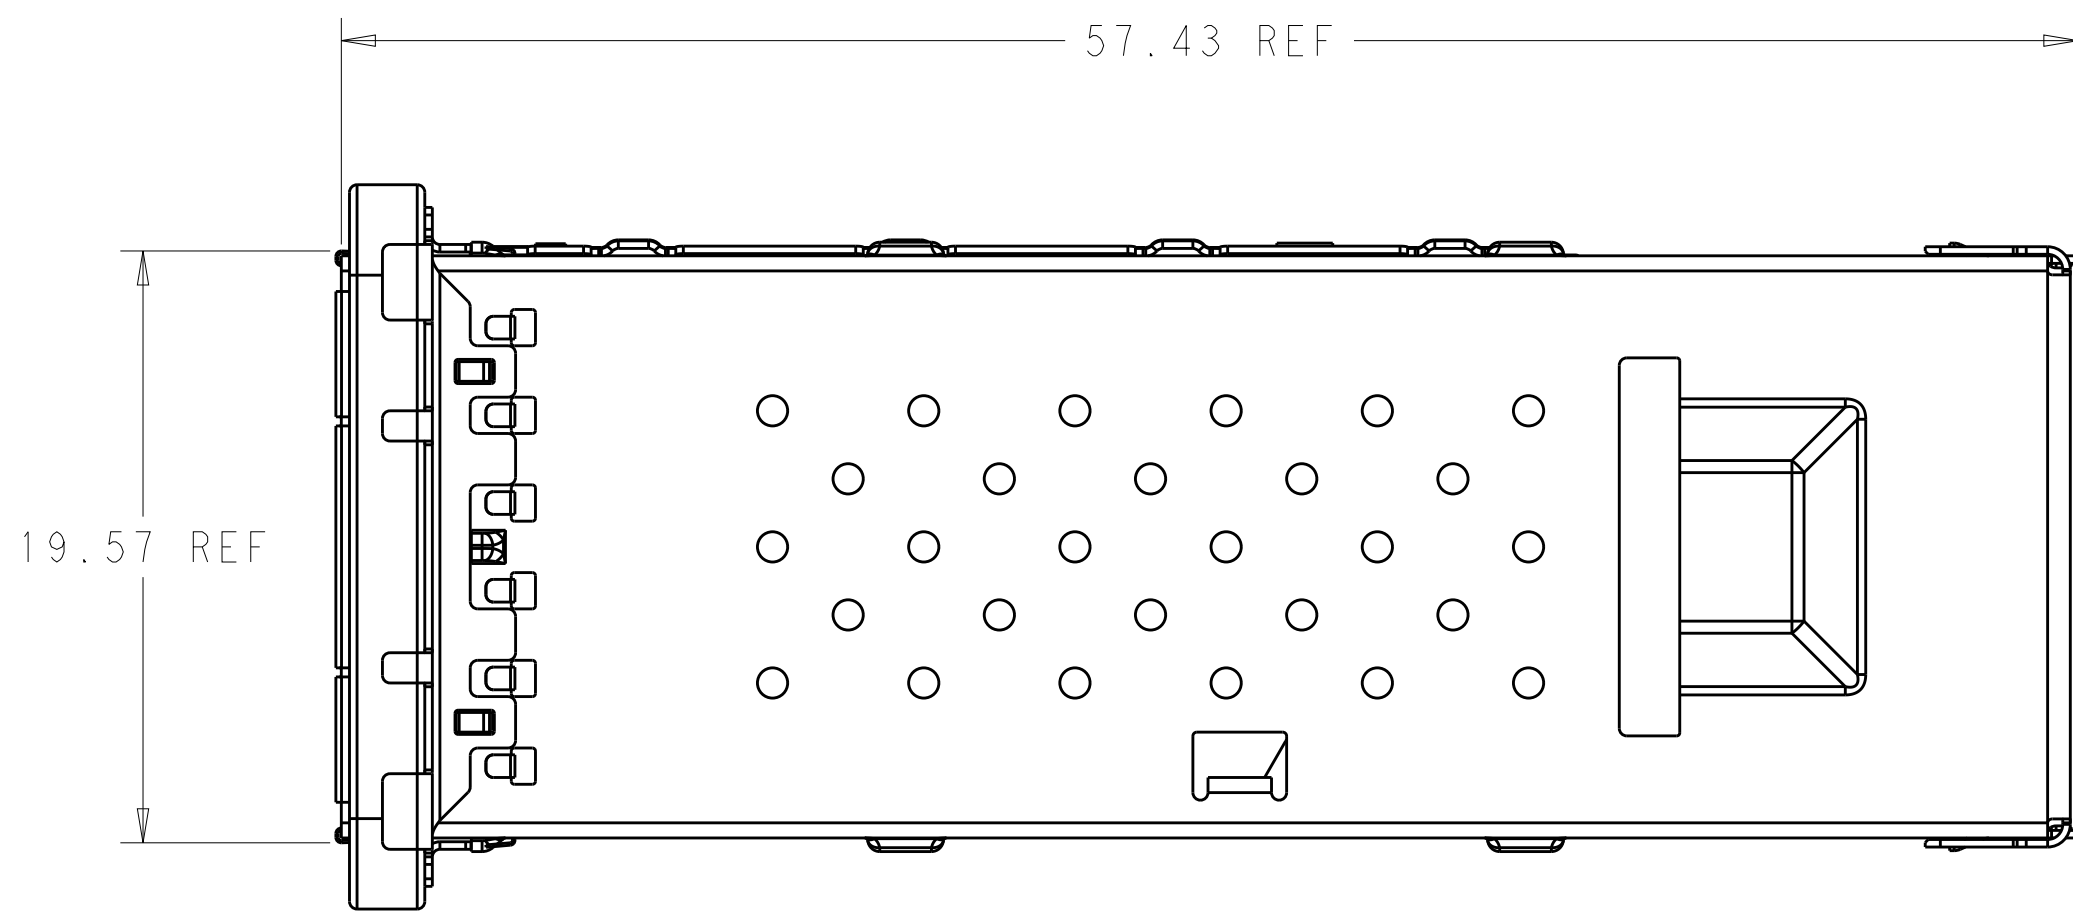

19.57 REF

57.43 REF


3. MATES WITH QSFP28 MSA COMPATIBLE TRANSCEIVER.

5 DATUM AND BASIC DIMENSIONS ESTABLISHED BY CUSTOMERS.

6. MINIMUM PC BOARD THICKNESS :
SINGLES SIDED: 1.57 MIN
DOUBLE SIDED: 3.00 MIN

 DATUM -A- IS TOP SURFACE OF THE HOST BOARD.

8 DATE CODE (YYWWD) MARKED APPROXIMATELY AS SHOWN

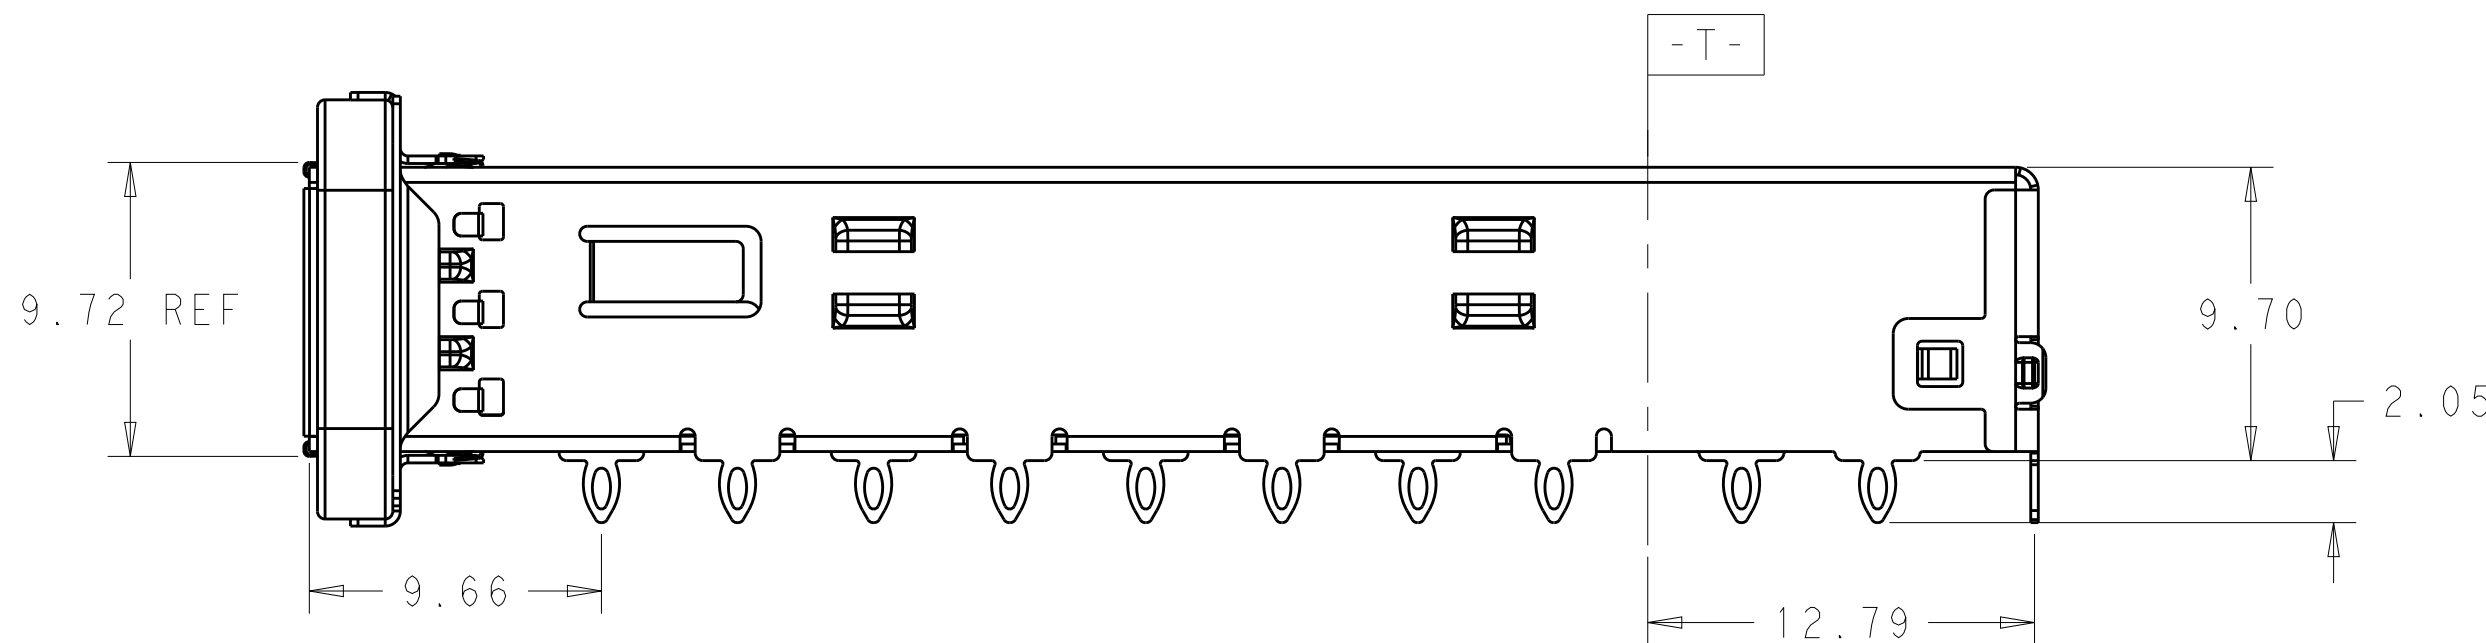


9.72 REF

$$8.90 \pm 0.1 \text{ C}$$

9.70

2.05

This technical floor plan shows a rectangular room. On the left side, there is a long desk with several chairs and a small cabinet. The central area is a large open space. On the right side, there is a large rectangular structure, possibly a stage or a large desk, with a smaller rectangular area in front of it. The plan includes various annotations such as dimensions, door locations, and furniture symbols.

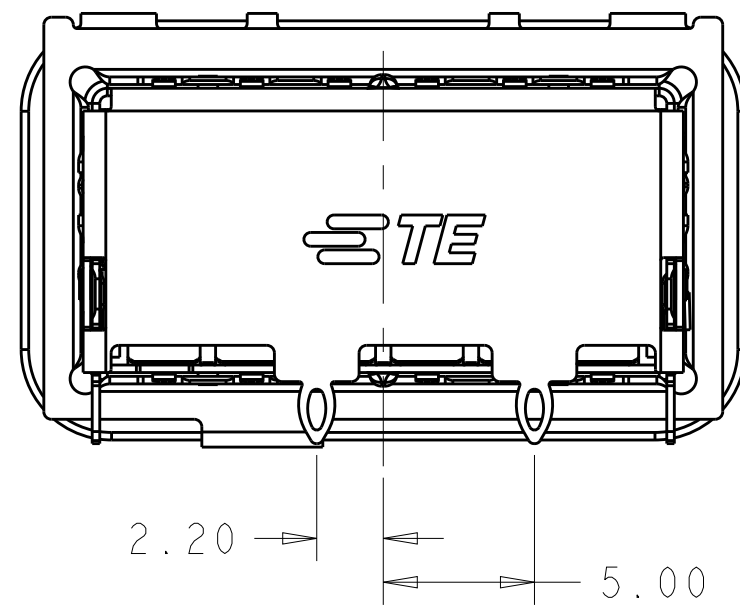


0	WITH	2170752-7
1	WITH	2170752-6
0	WITHOUT	2170752-5
1	WITHOUT	2170752-4
2	WITH	2170752-2
2	WITHOUT	2170752-1
# REAR PINS	HEAT SINK OPEN	PART NUMBER

THIS DRAWING IS A CONTROLLED DOCUMENT.		DWN JASON YANG 01APR2014		 TE Connectivity	
		CHK SEAN HAN 30DEC2015			
DIMENSIONS:		TOLERANCES UNLESS OTHERWISE SPECIFIED:		NAME	
mm				AGE ASSEMBLY, QSFP28 1X1, THRU BEZEL WITH EMI GASKET	
		PRODUCT SPEC 108-19428 APPLICATION SPEC 114-32023		SIZE CAGE CODE DRAWING NO	
MATERIAL		FINISH		RESTRICTED TO	
				A100779 ©=2170752	
CUSTOMER DRAWING				SCALE 4:1	SHEET 1 OF 5 REV A


2170752-1 AS SHOWN

LOC	DIST	REVISIONS						
		P	LTR	DESCRIPTION	DATE	DWN	APVD	
			-	SEE SHEET 1		-	-	-

HEAT SINK OPEN OPTIONS

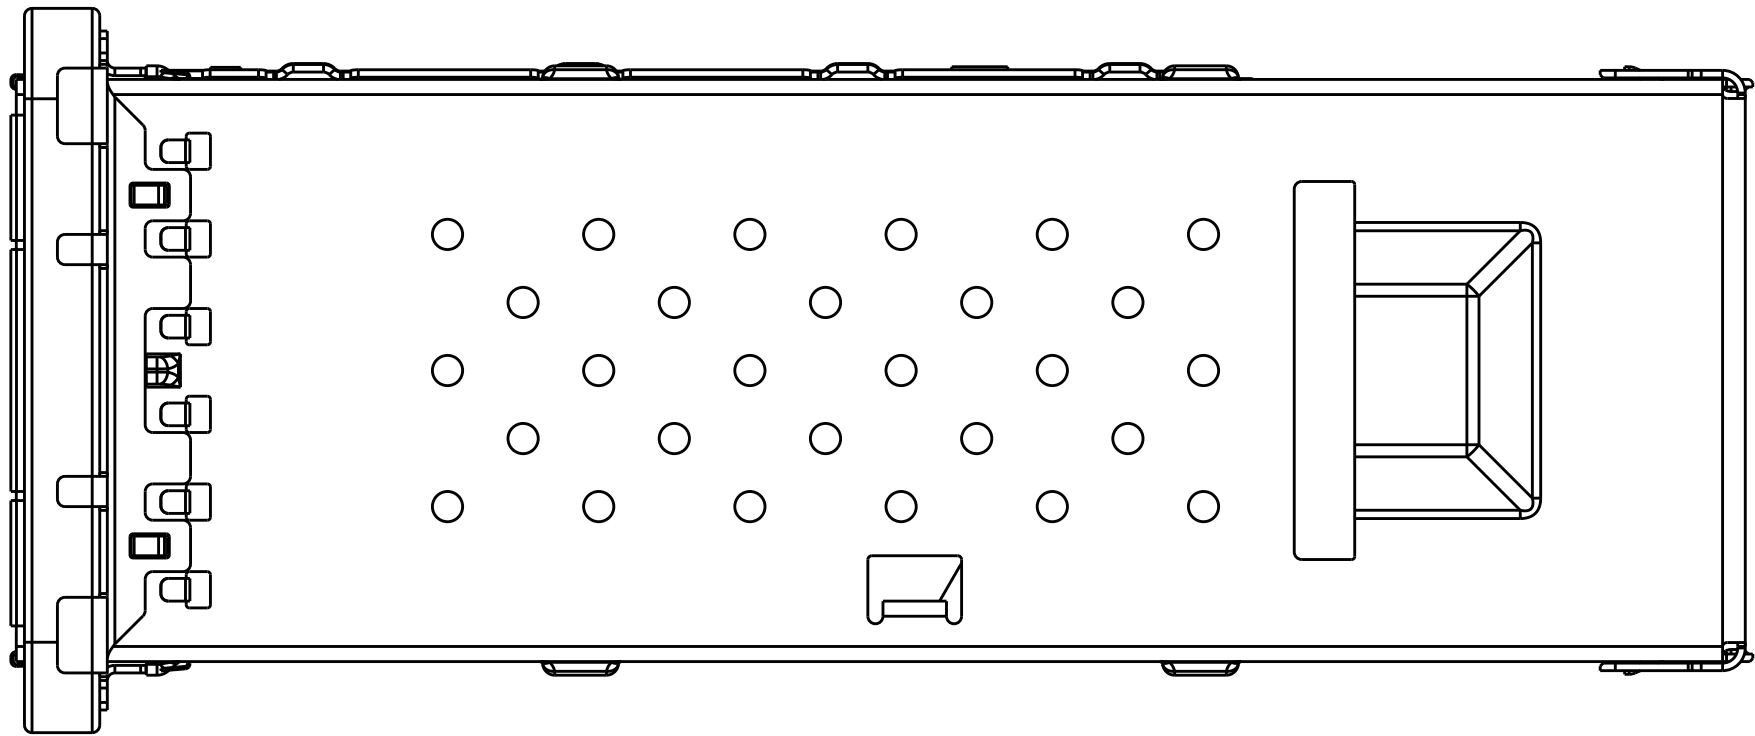


WITHOUT HEAT SINK OPEN
SCALE 4:1

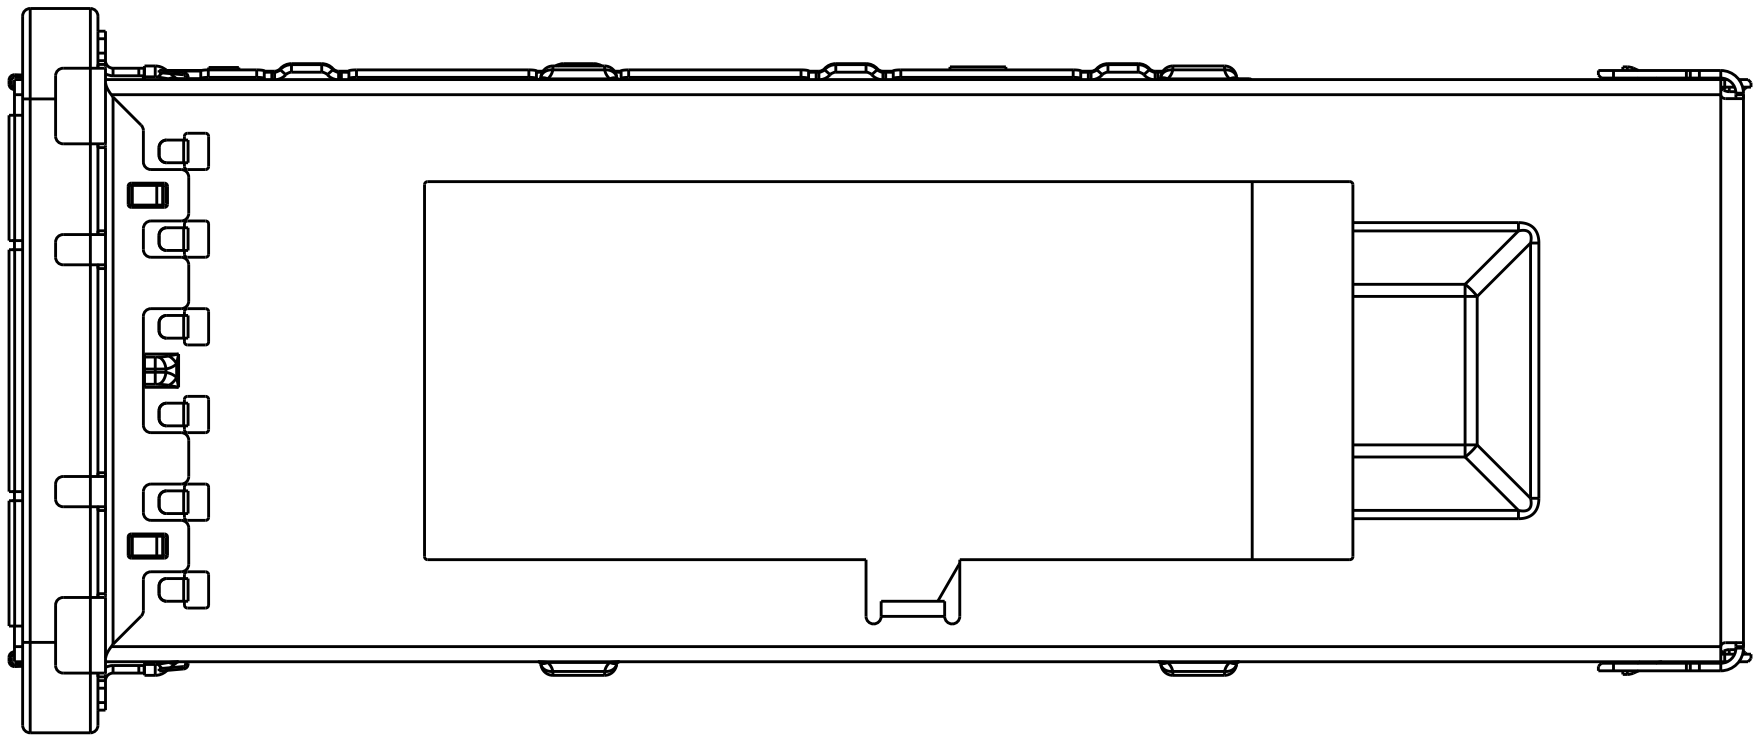


WITH HEAT SINK OPEN
SCALE 4:1

OF REAR LEGS OPTIONS

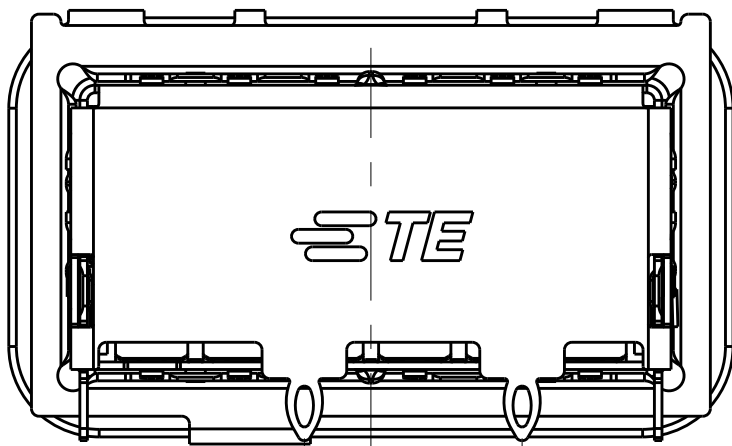


(2.20) (5.00)

2 REAR LEGS VERSION
SCALE 4:1

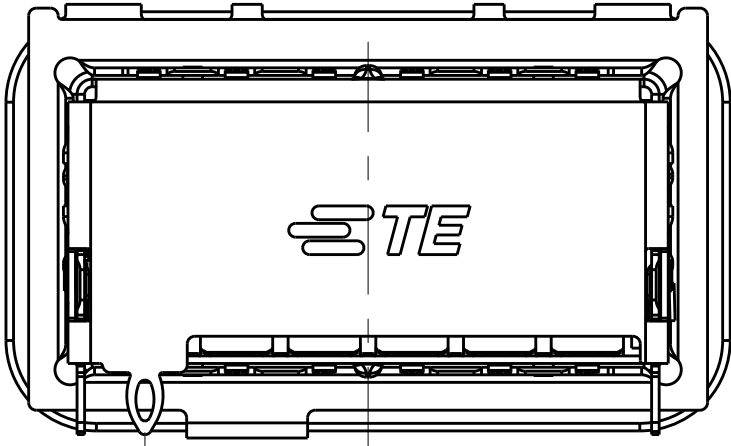

7.38





1 REAR LEG VERSION
SCALE 4:1

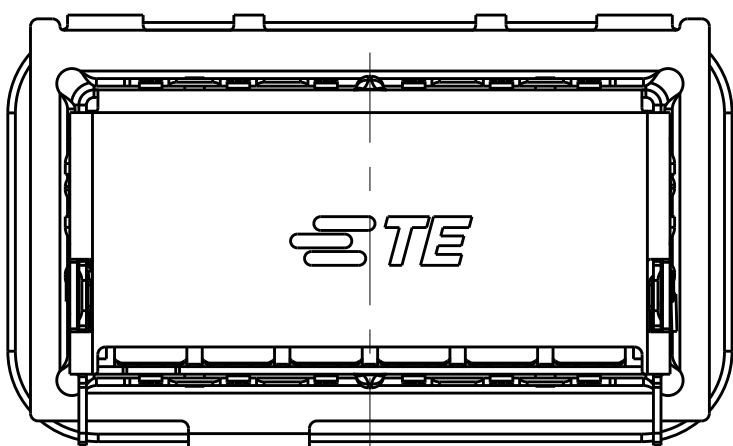

0 REAR LEG VERSION
SCALE 4:1



THIS DRAWING IS A CONTROLLED DOCUMENT.		DWN: JASON YANG 01APR2014 CHK: SEAN HAN 30DEC2015 APVD: -	TE Connectivity	
DIMENSIONS: mm		0 PLC ±0.25 1 PLC ±0.25 2 PLC ±0.20 3 PLC ±0.100 4 PLC ± ANGLES ± FINISH -	PRODUCT SPEC: 108-19428 APPLICATION SPEC: 114-32023 WEIGHT: - Customer Drawing	NAME: CAGE ASSEMBLY, OSFP28 1X1, THRU BEZEL WITH EMI GASKET SIZE: A100779 CAGE CODE: C=2170752
MATERIAL: -		RESTRICTED TO: -		
		SCALE: 4:1 SHEET: 2 OF 5 REV: A		

LOC		DIST		REVISIONS			
P	LTR	DESCRIPTION		DATE	DWN	APVD	
-	-	SEE SHEET 1		-	-	-	

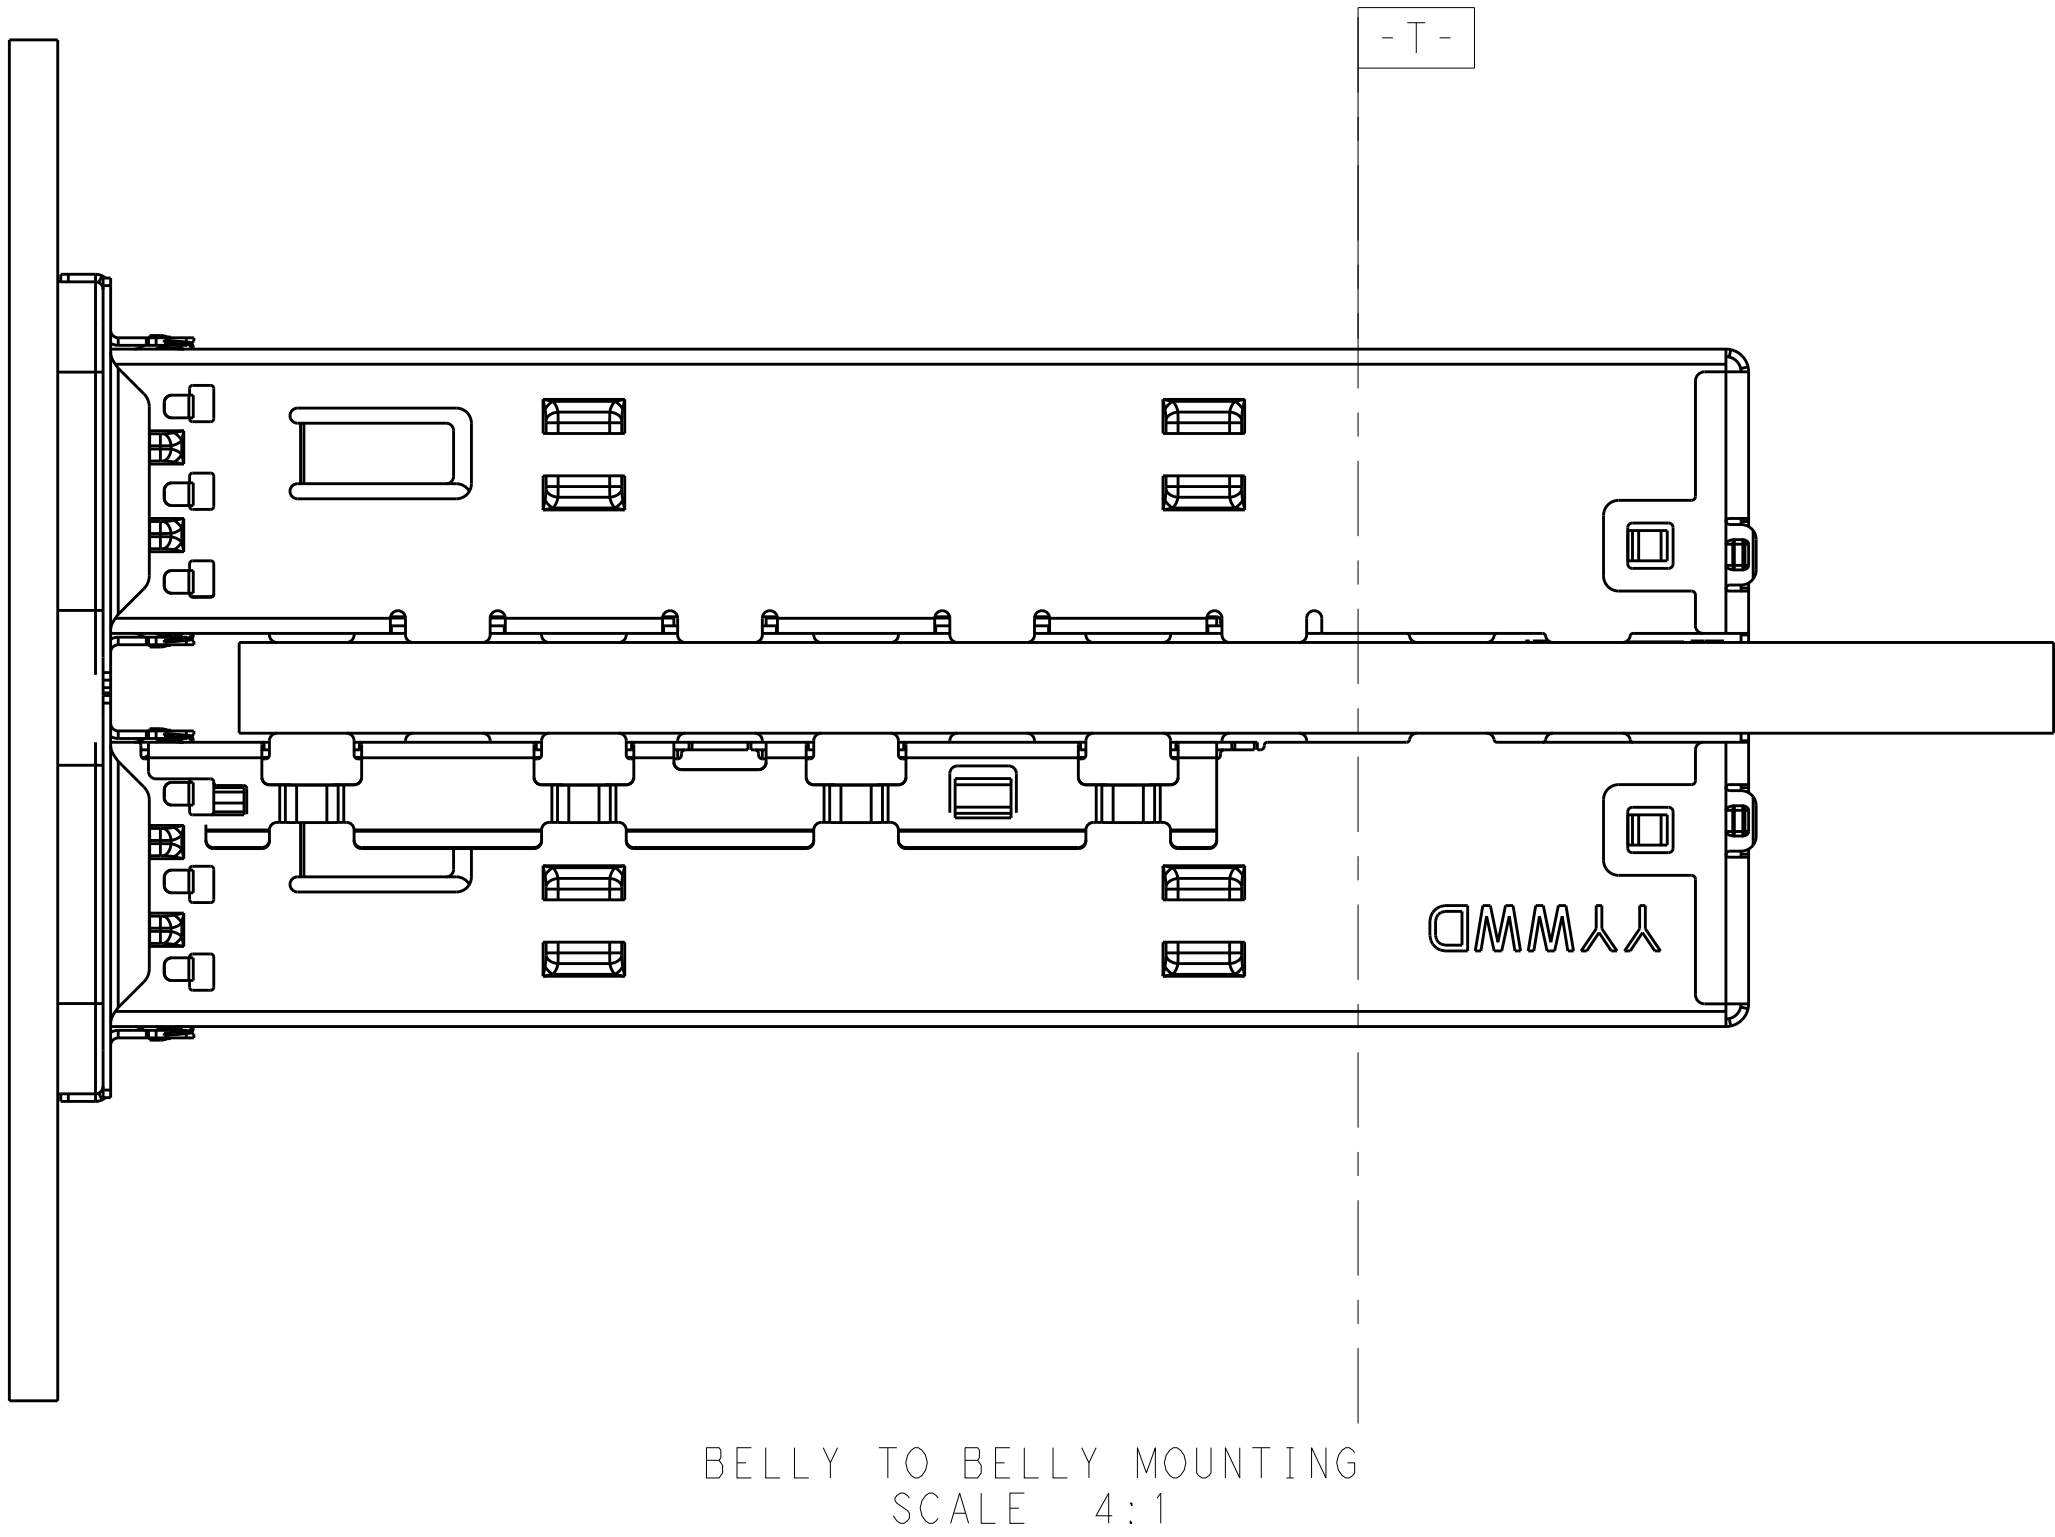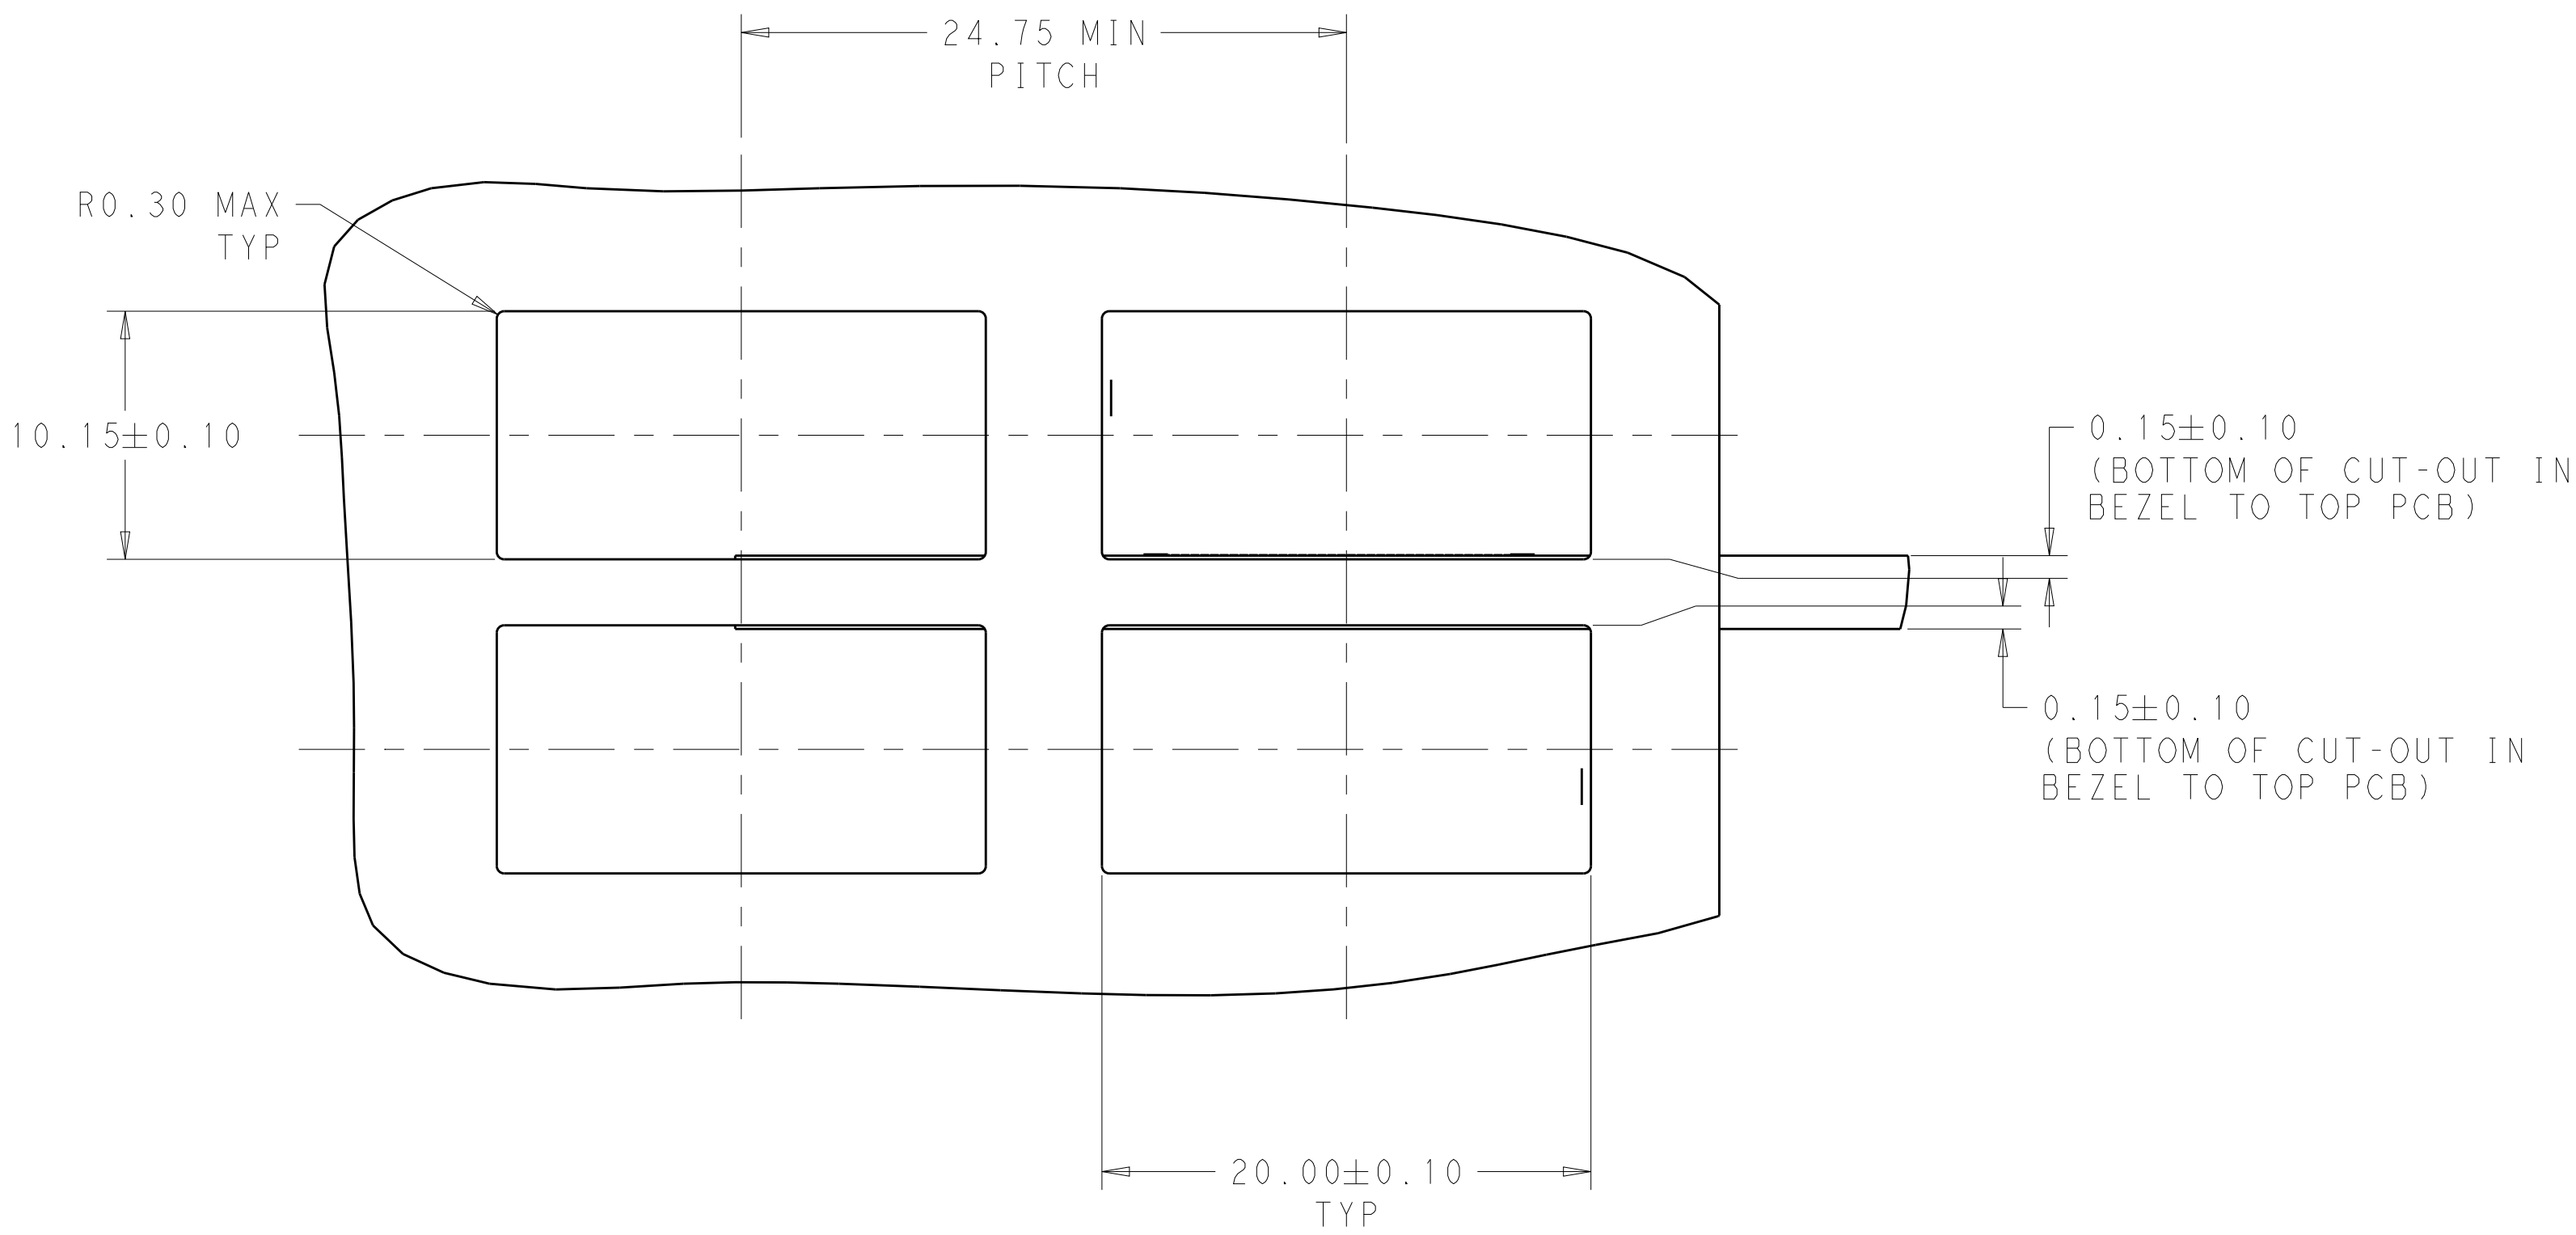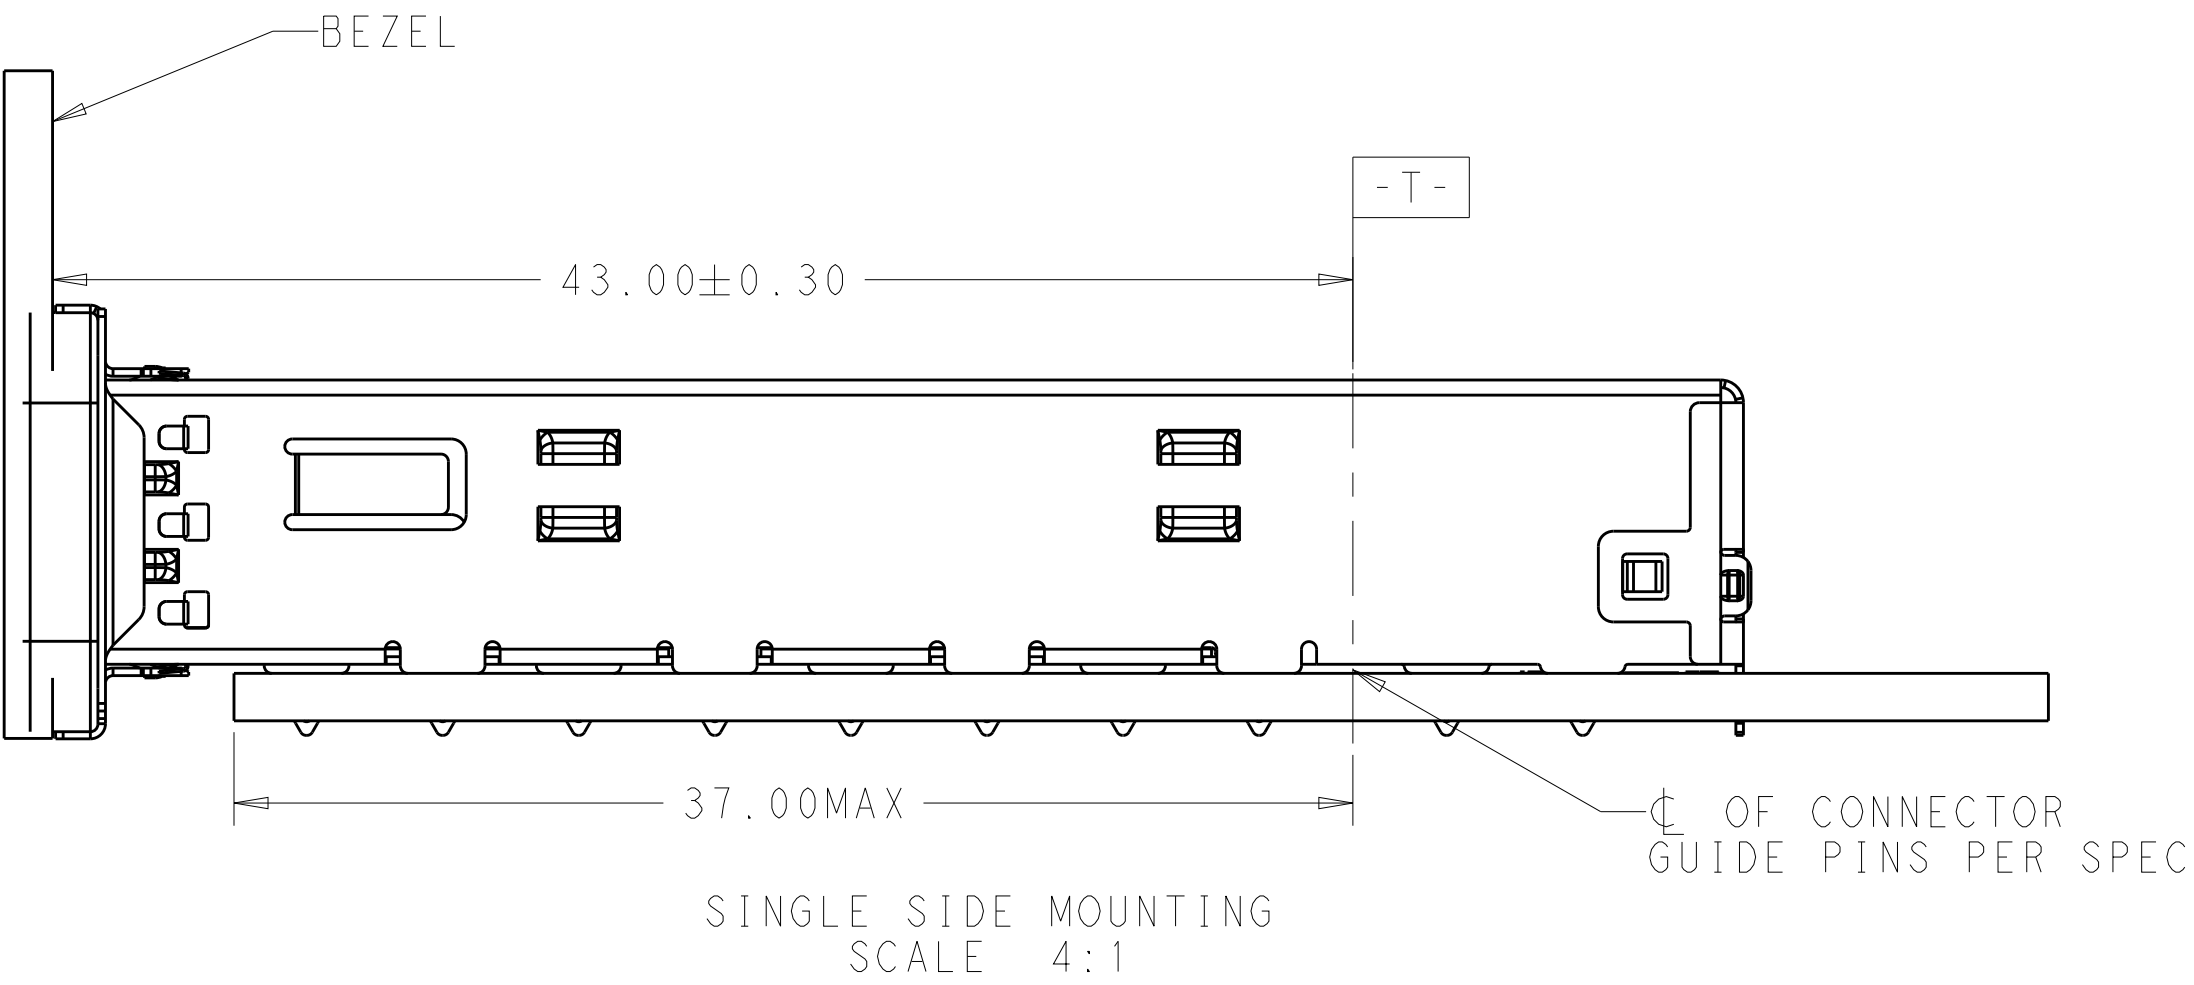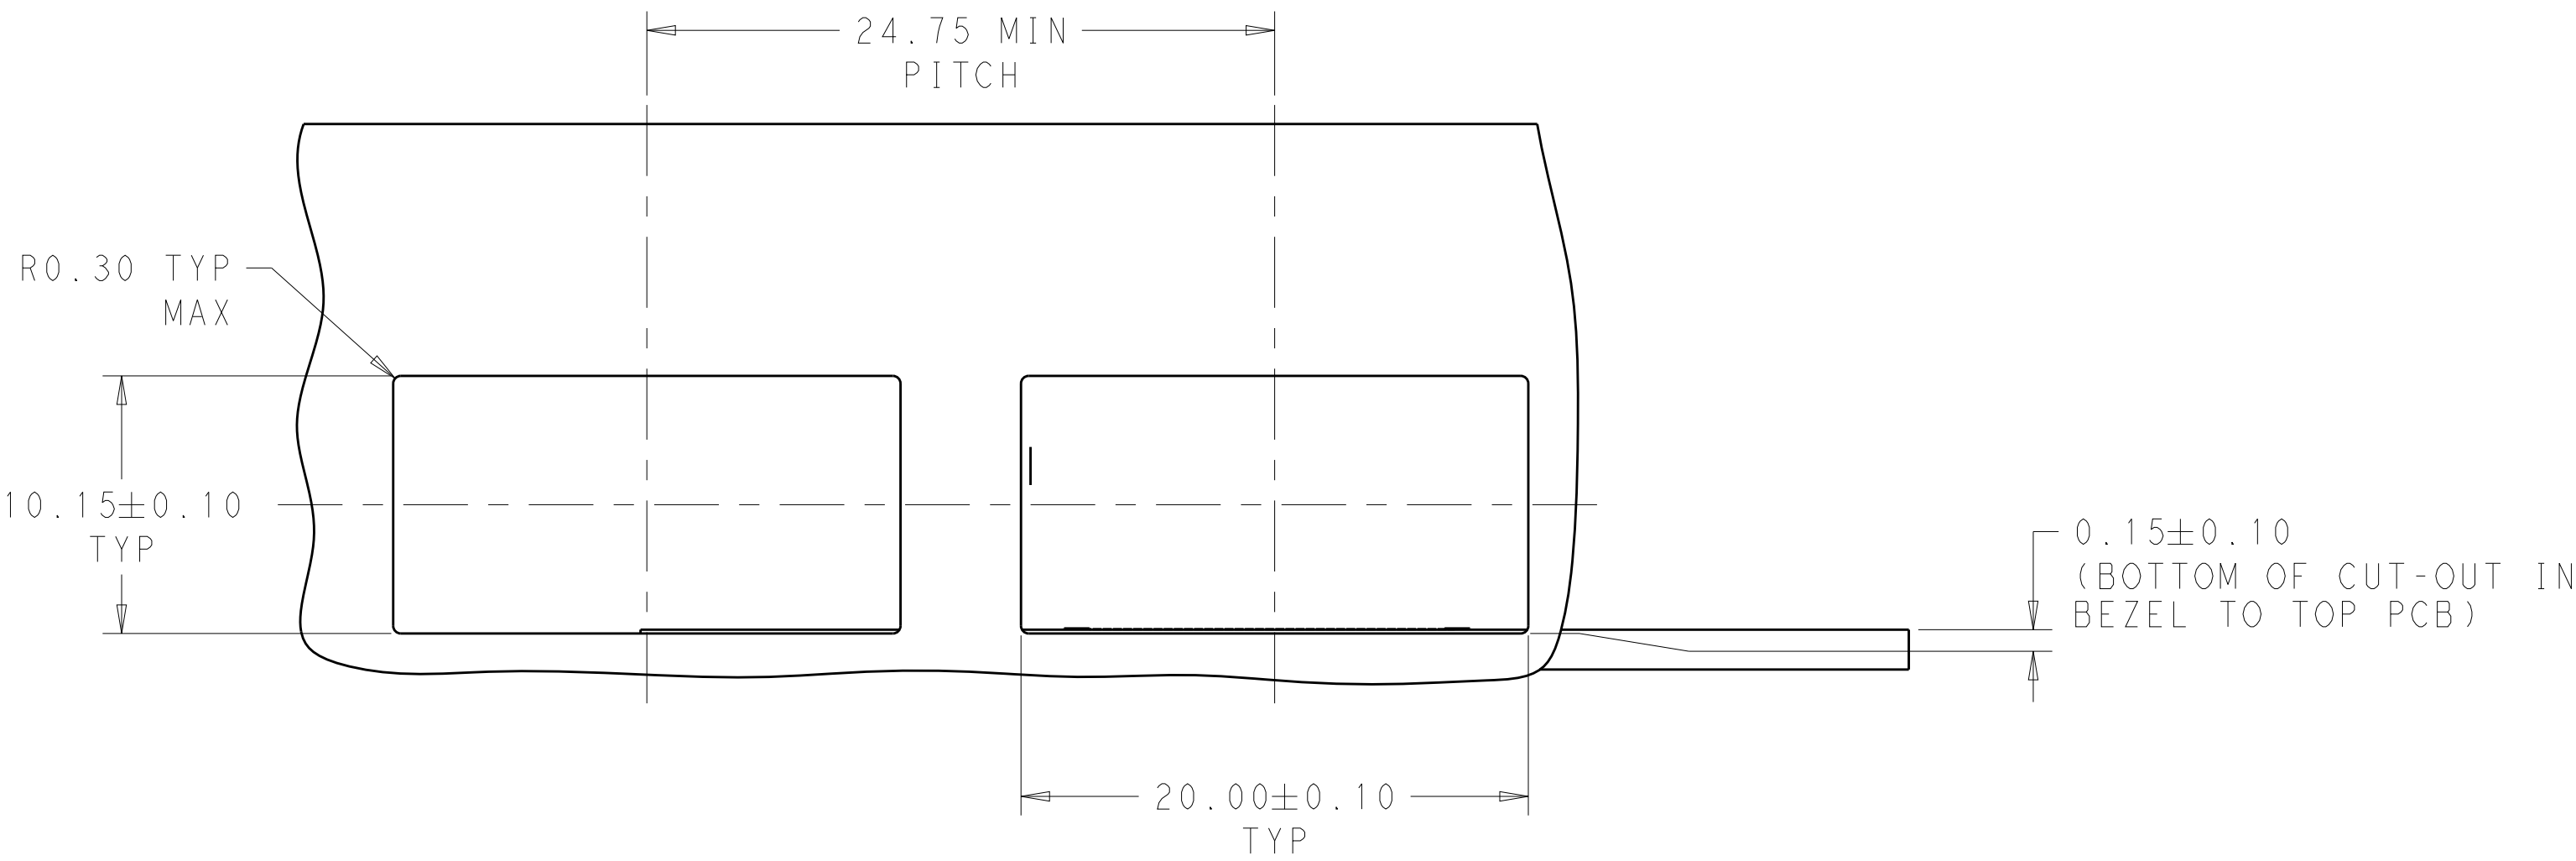


THIS DRAWING IS A CONTROLLED DOCUMENT.		DWN JASON YANG 01APR2014	TE Connectivity
		CHK SEAN HAN 30DEC2015	
DIMENSIONS:		APVD -	NAME
mm		PRODUCT SPEC	CAGE ASSEMBLY, OSFP28 1X1, THRU BEZEL
		108-19428	WITH EMI GASKET
		APPLICATION SPEC	-
		114-32023	SIZE CAGE CODE DRAWING NO
		WEIGHT	A100779C=2170752
MATERIAL		Customer Drawing	RESTRICTED TO
-			-
-			
		SCALE 4:1	SHEET 3 OF 5
			REV A


LOC	DIST	REVISIONS					
		P	LTR	DESCRIPTION	DATE	DWN	APVD
		-		SEE SHEET 1	-	-	-

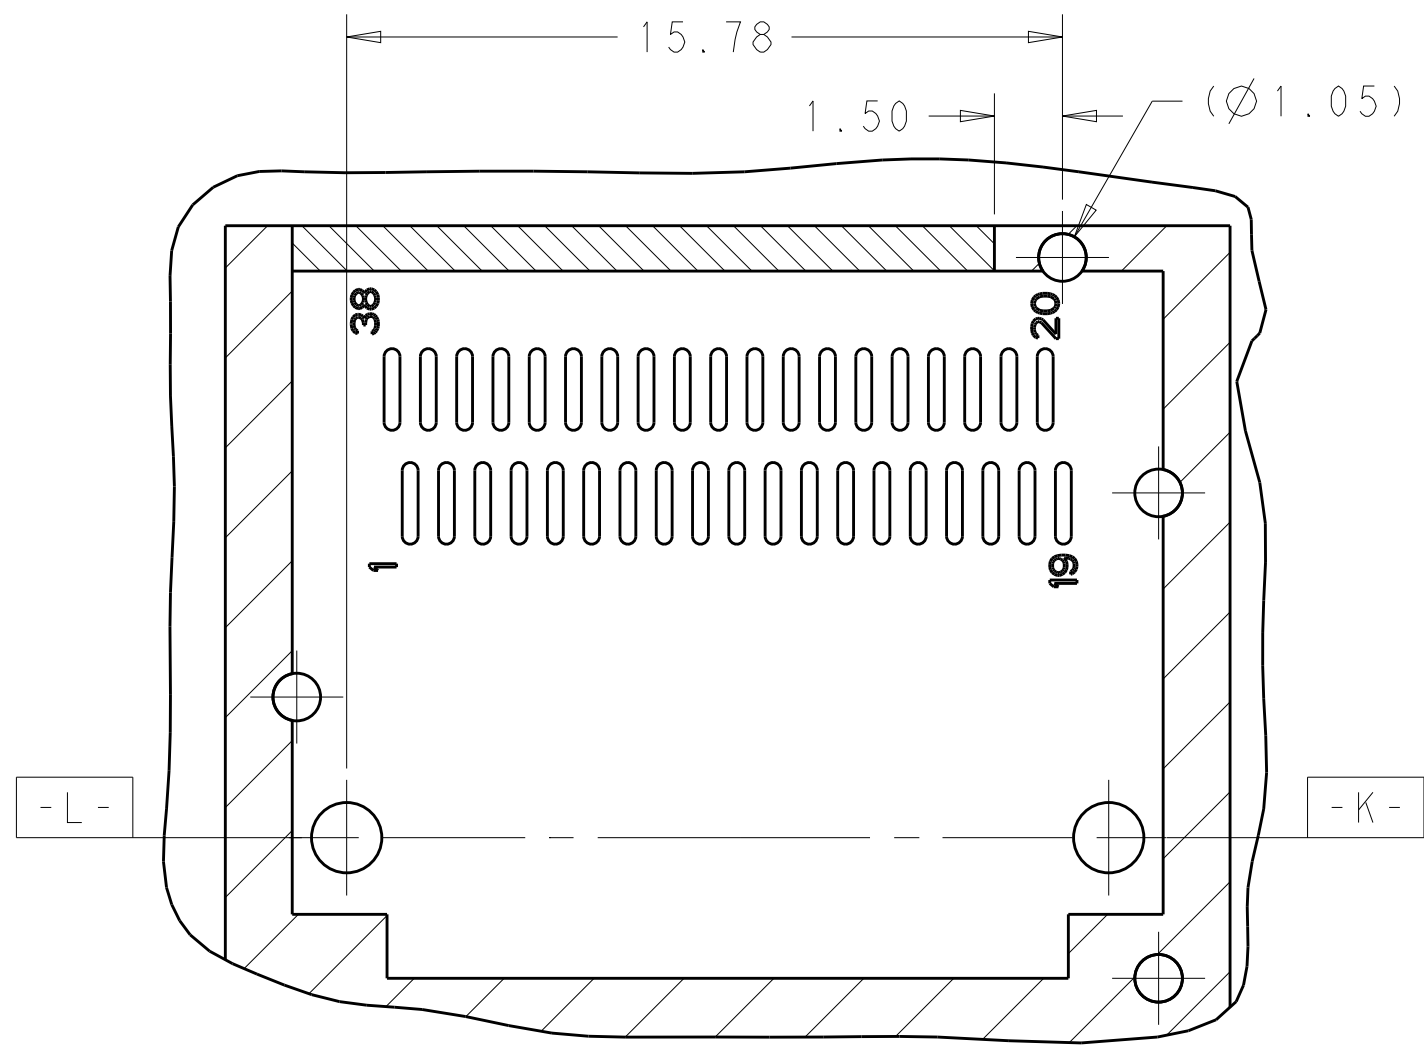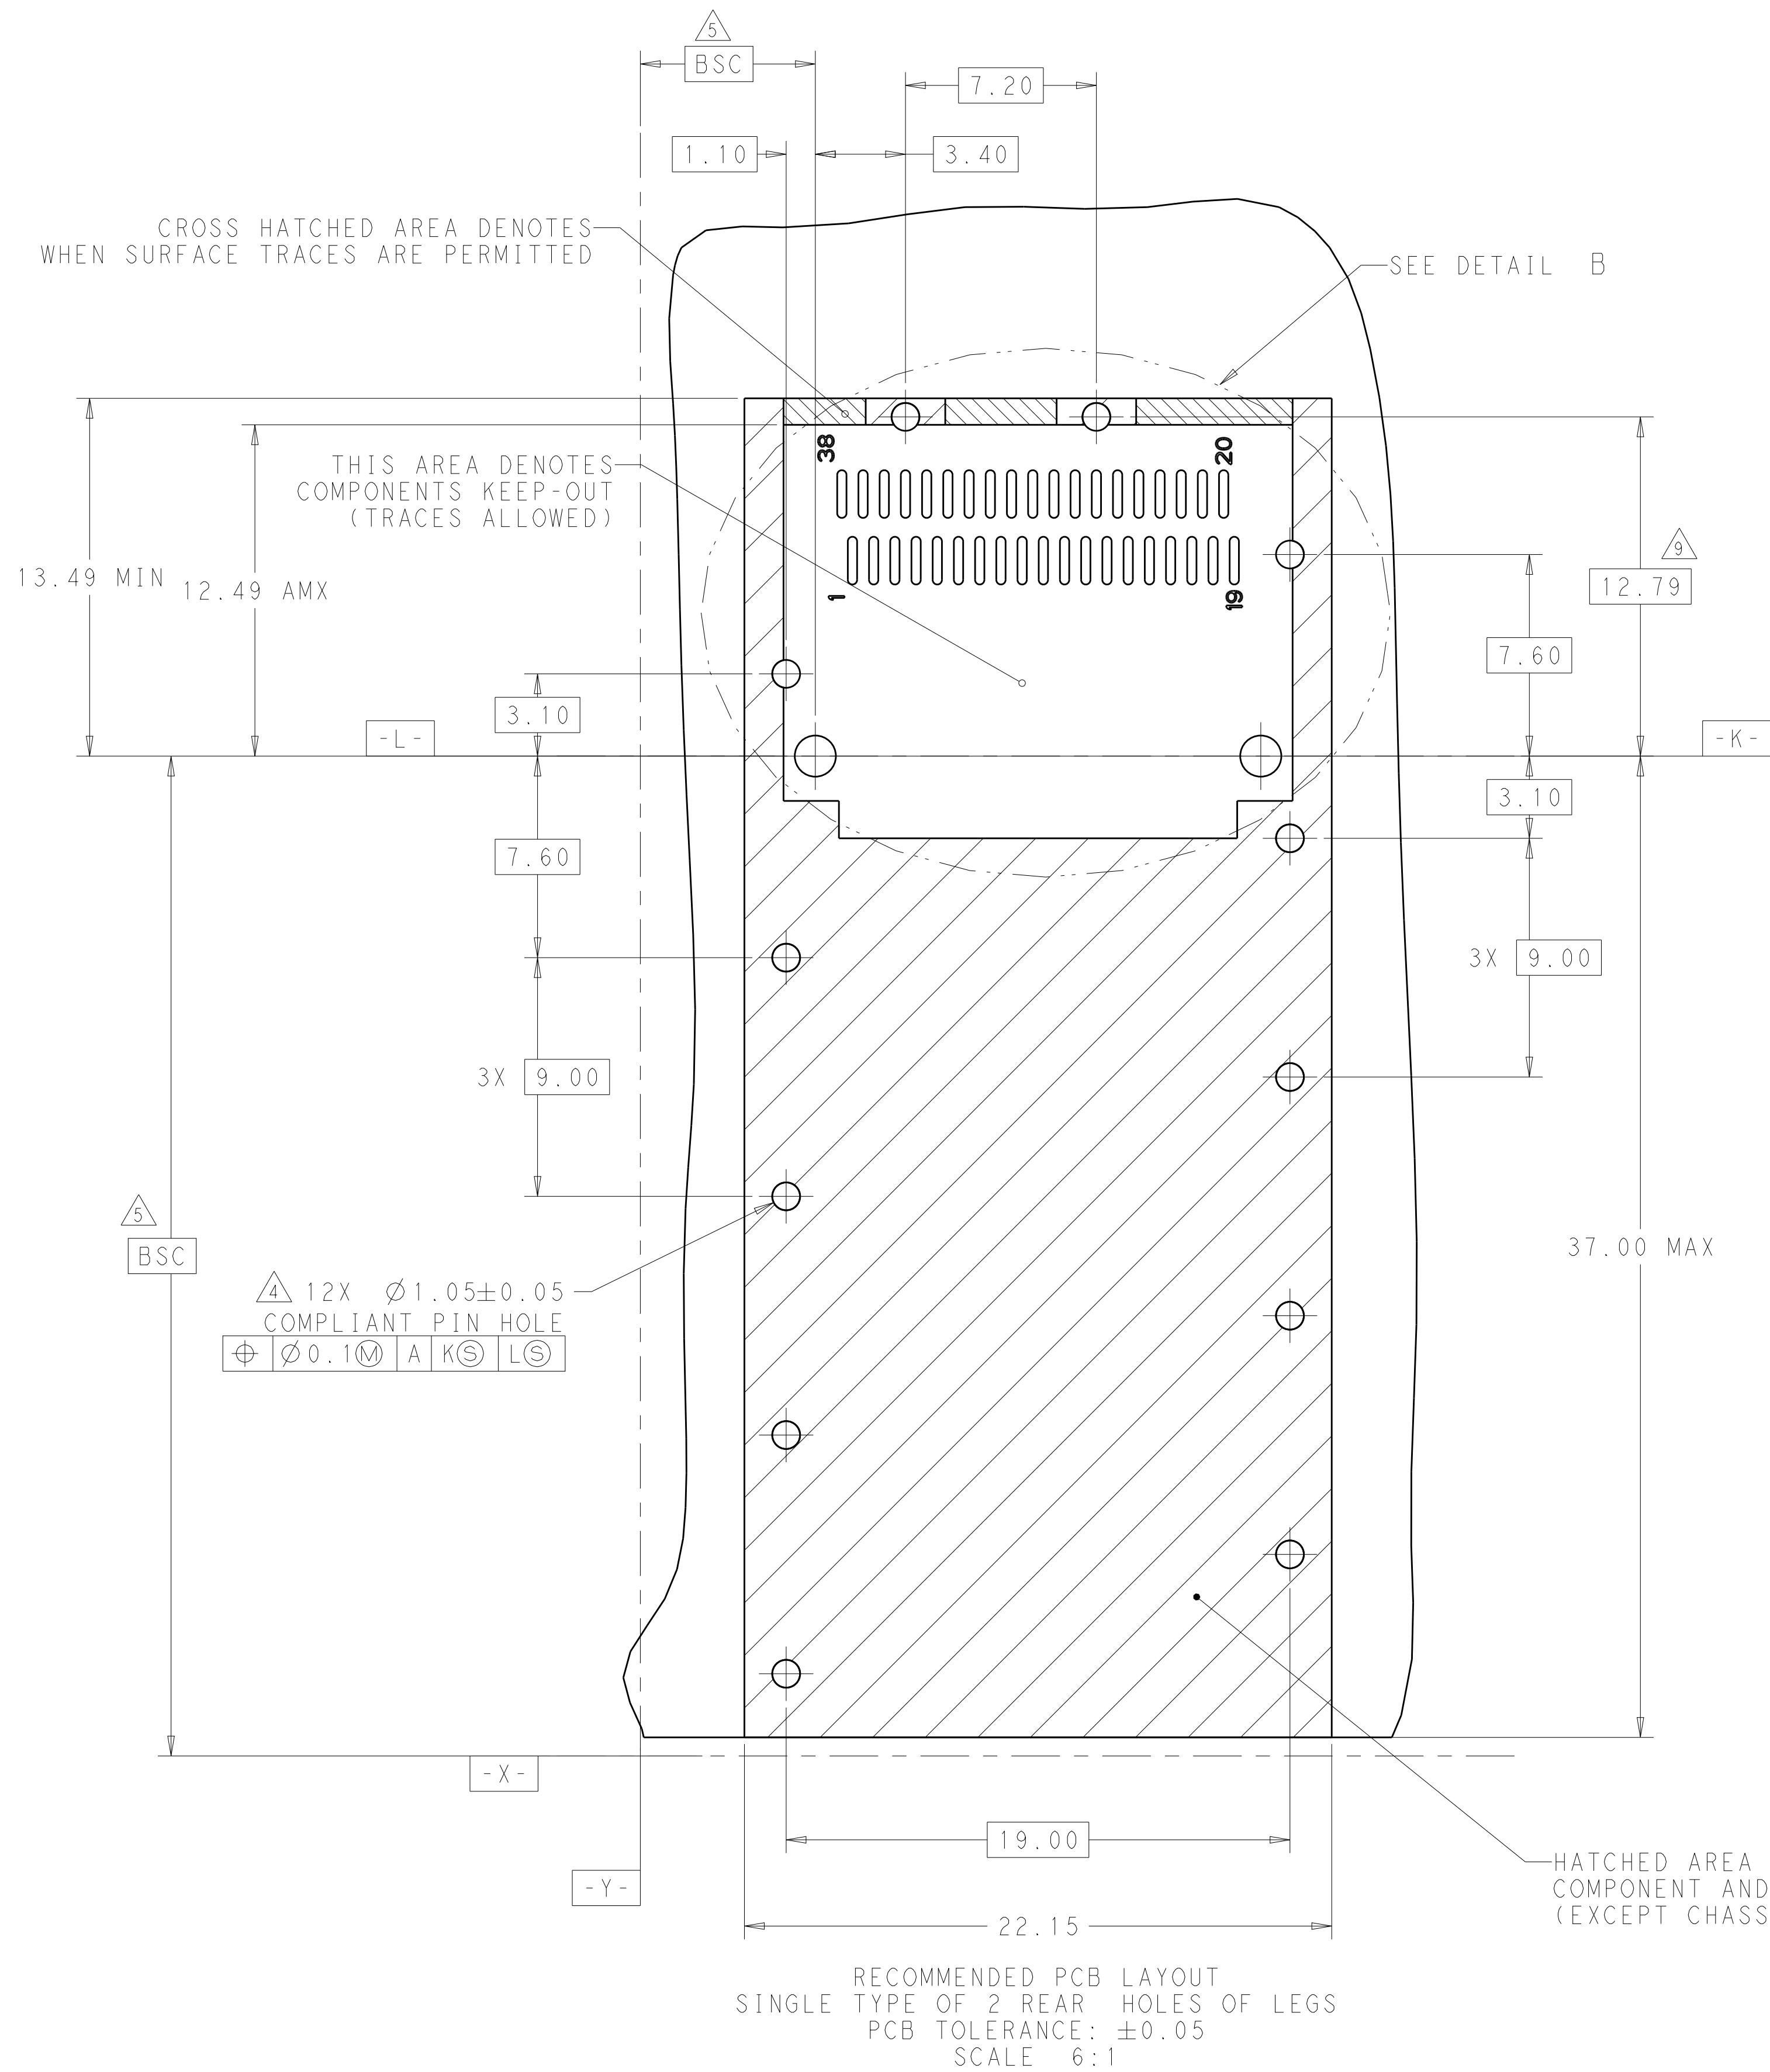

RECOMMENDED PCB LAYOUT
SINGLE TYPE OF 1 REAR HOLES OF LEGS
PCB TOLERANCE: ± 0.05
SCALE 6:1

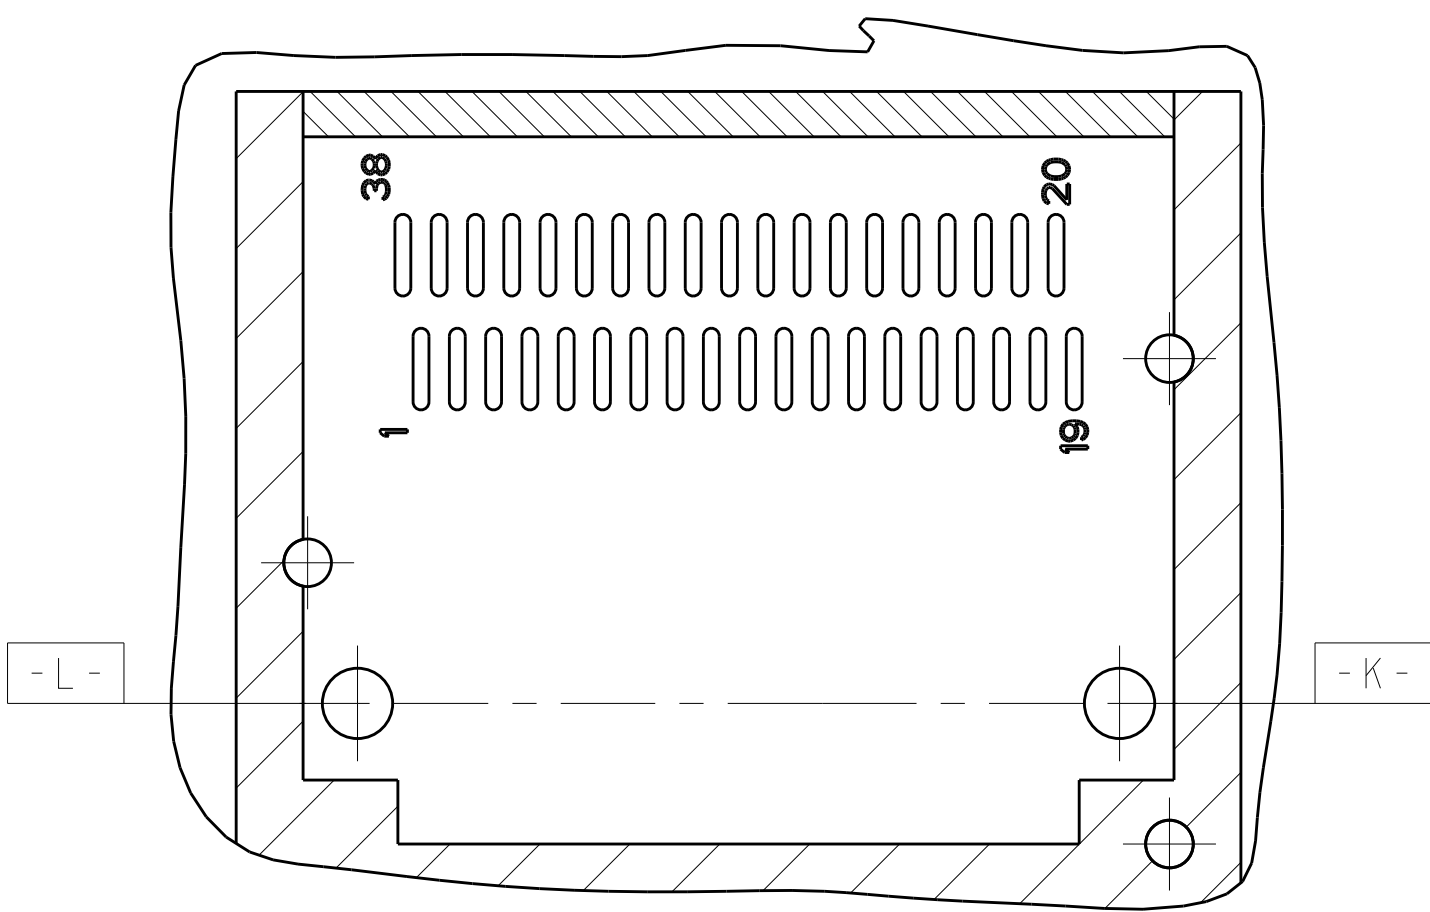


RECOMMENDED PCB LAYOUT
SINGLE TYPE OF 0 REAR HOLES OF LEGS
PCB TOLERANCE: ± 0.05
SCALE 6:1

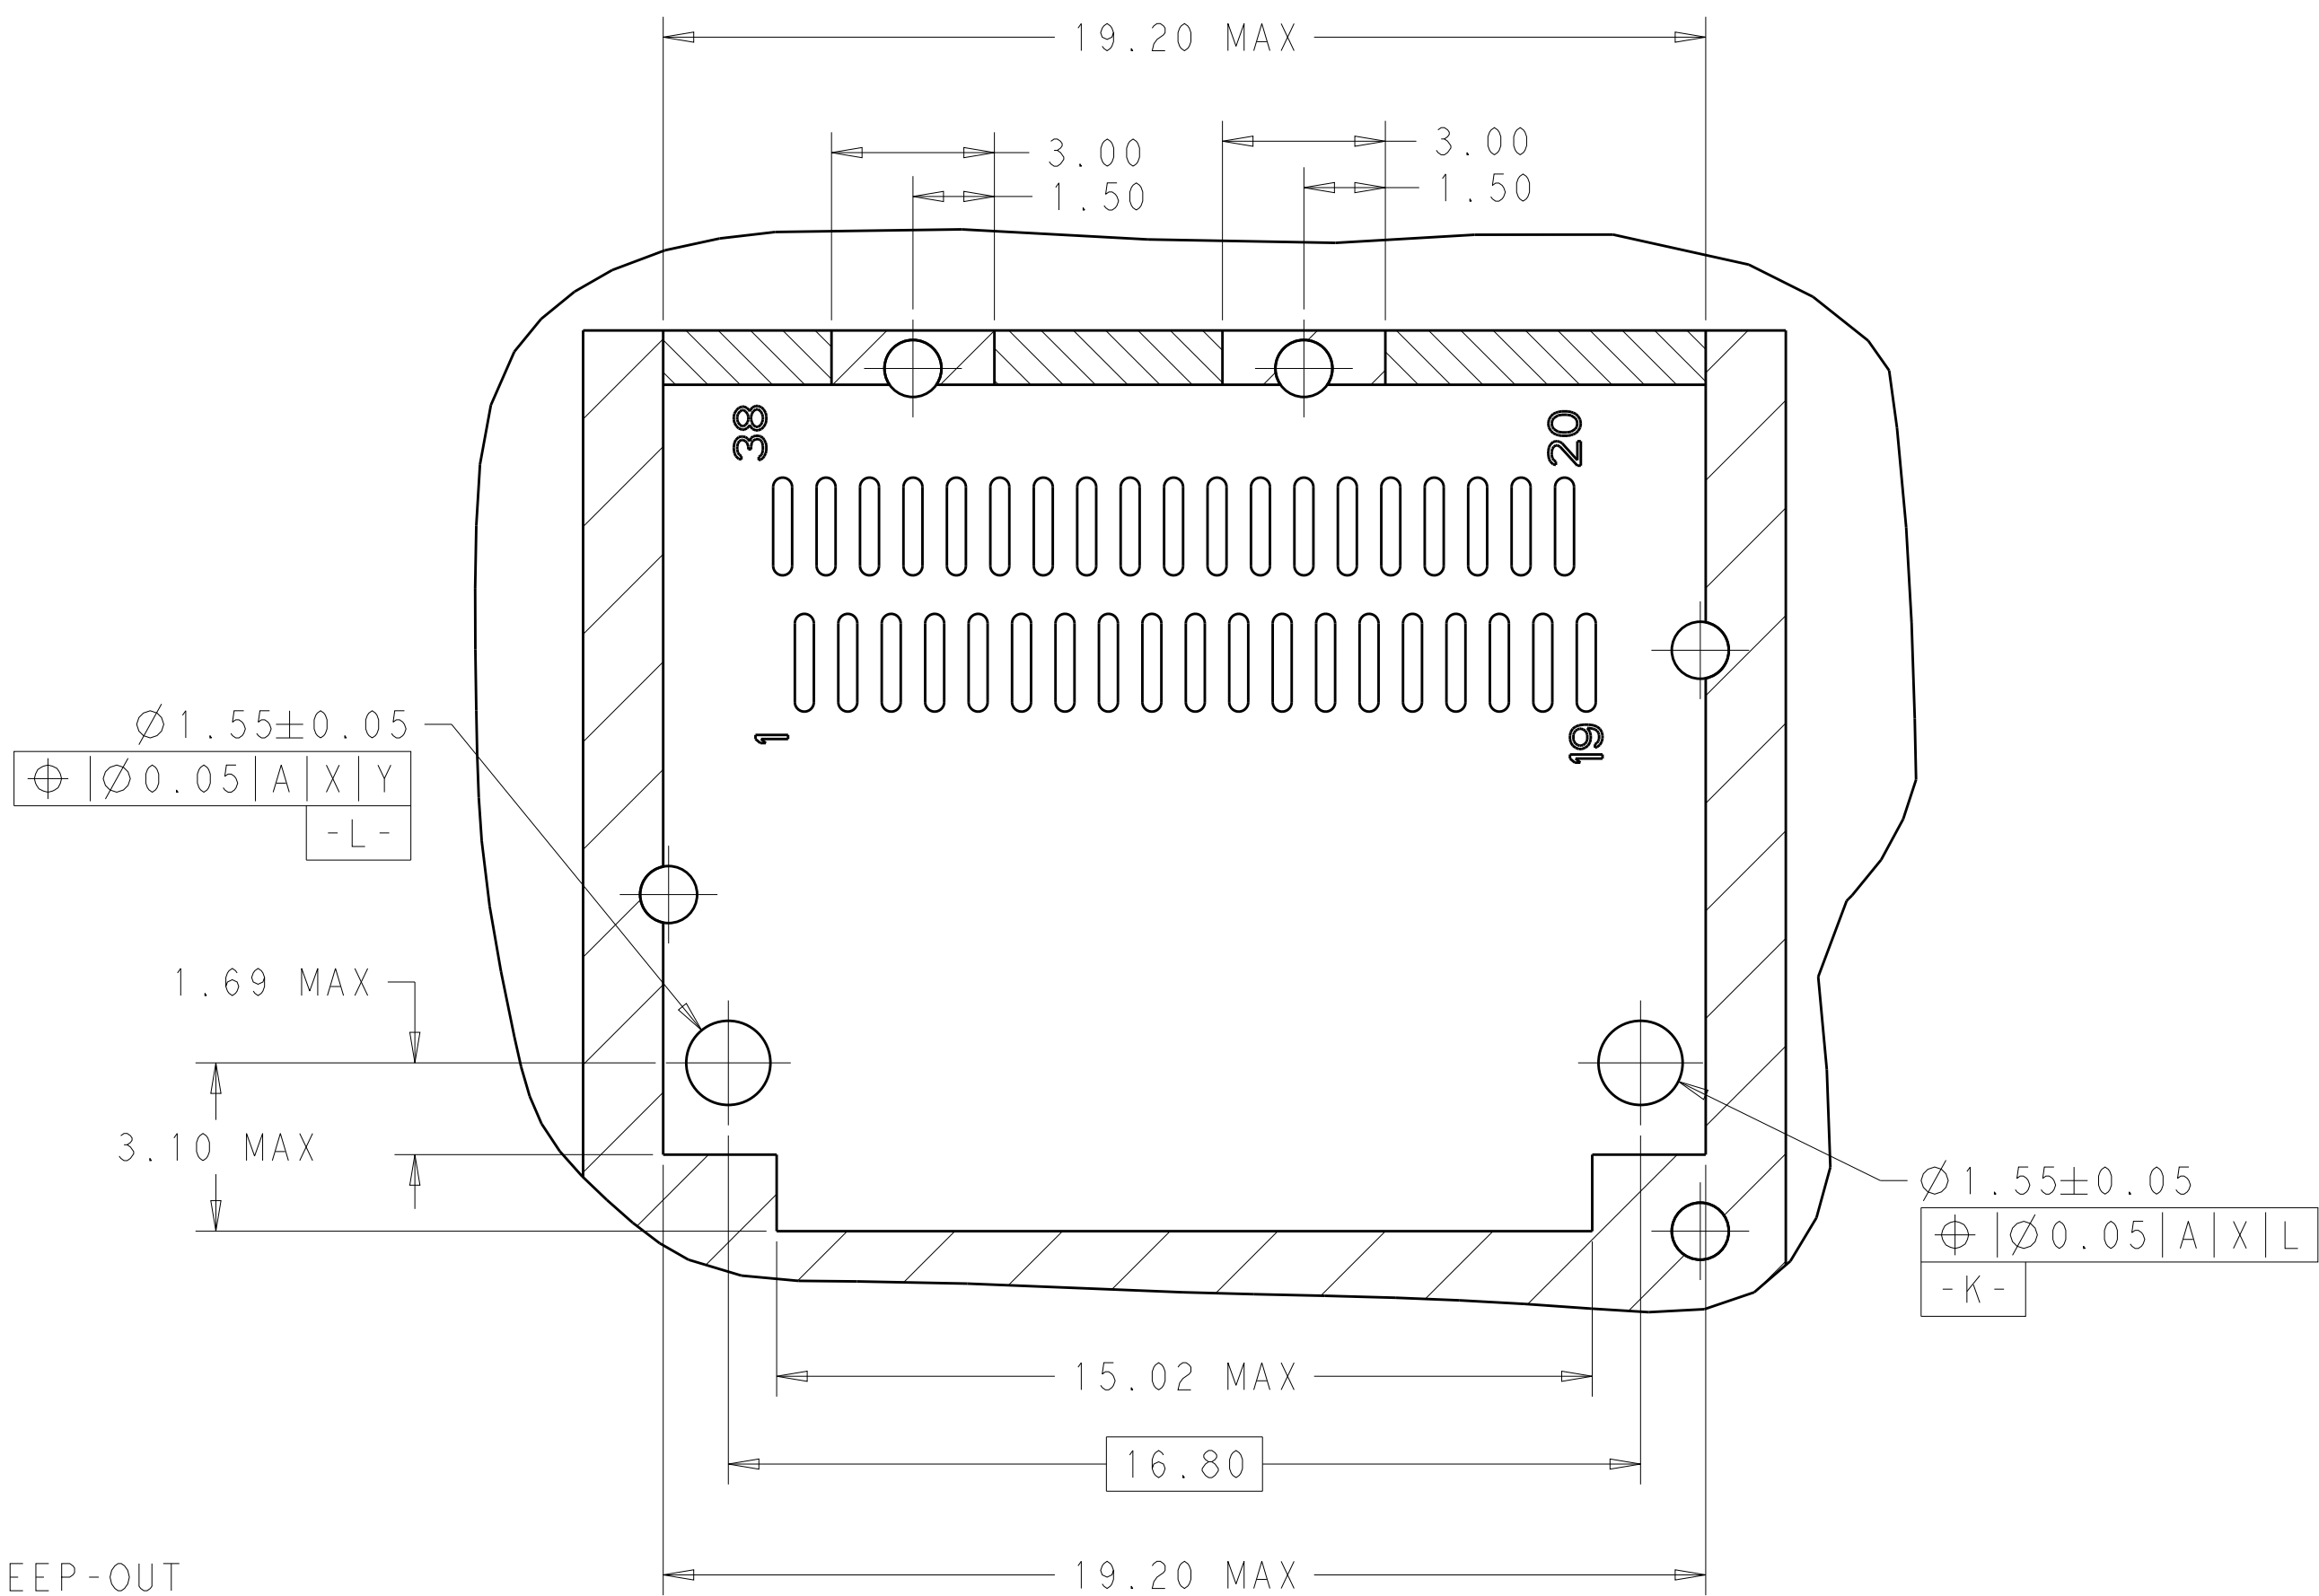

DETAIL B
SCALE 8:1

THIS DRAWING IS A CONTROLLED DOCUMENT.		DWN: JASON YANG 01APR2014	TE Connectivity	
DIMENSIONS:		CHK: SEAN HAN 30DEC2015		
mm	TOLERANCES UNLESS OTHERWISE SPECIFIED:	APVD: -	NAME: CAGE ASSEMBLY, OSFP28 1X1, THRU BEZEL WITH EMI GASKET	
	0 PLC ± 0.25 1 PLC ± 0.25 2 PLC ± 0.25 3 PLC ± 0.100 4 PLC $\pm$ ANGLES $\pm$ FINISH	PRODUCT SPEC: 108-19428 APPLICATION SPEC: 114-32023 WEIGHT: -	SIZE: CAGE CODE: DRAWING NO: A100779C=2170752	
MATERIAL: -	-	Customer Drawing	RESTRICTED TO: -	
		SCALE: 4:1	SHEET 4 OF 5	
			REV: A	

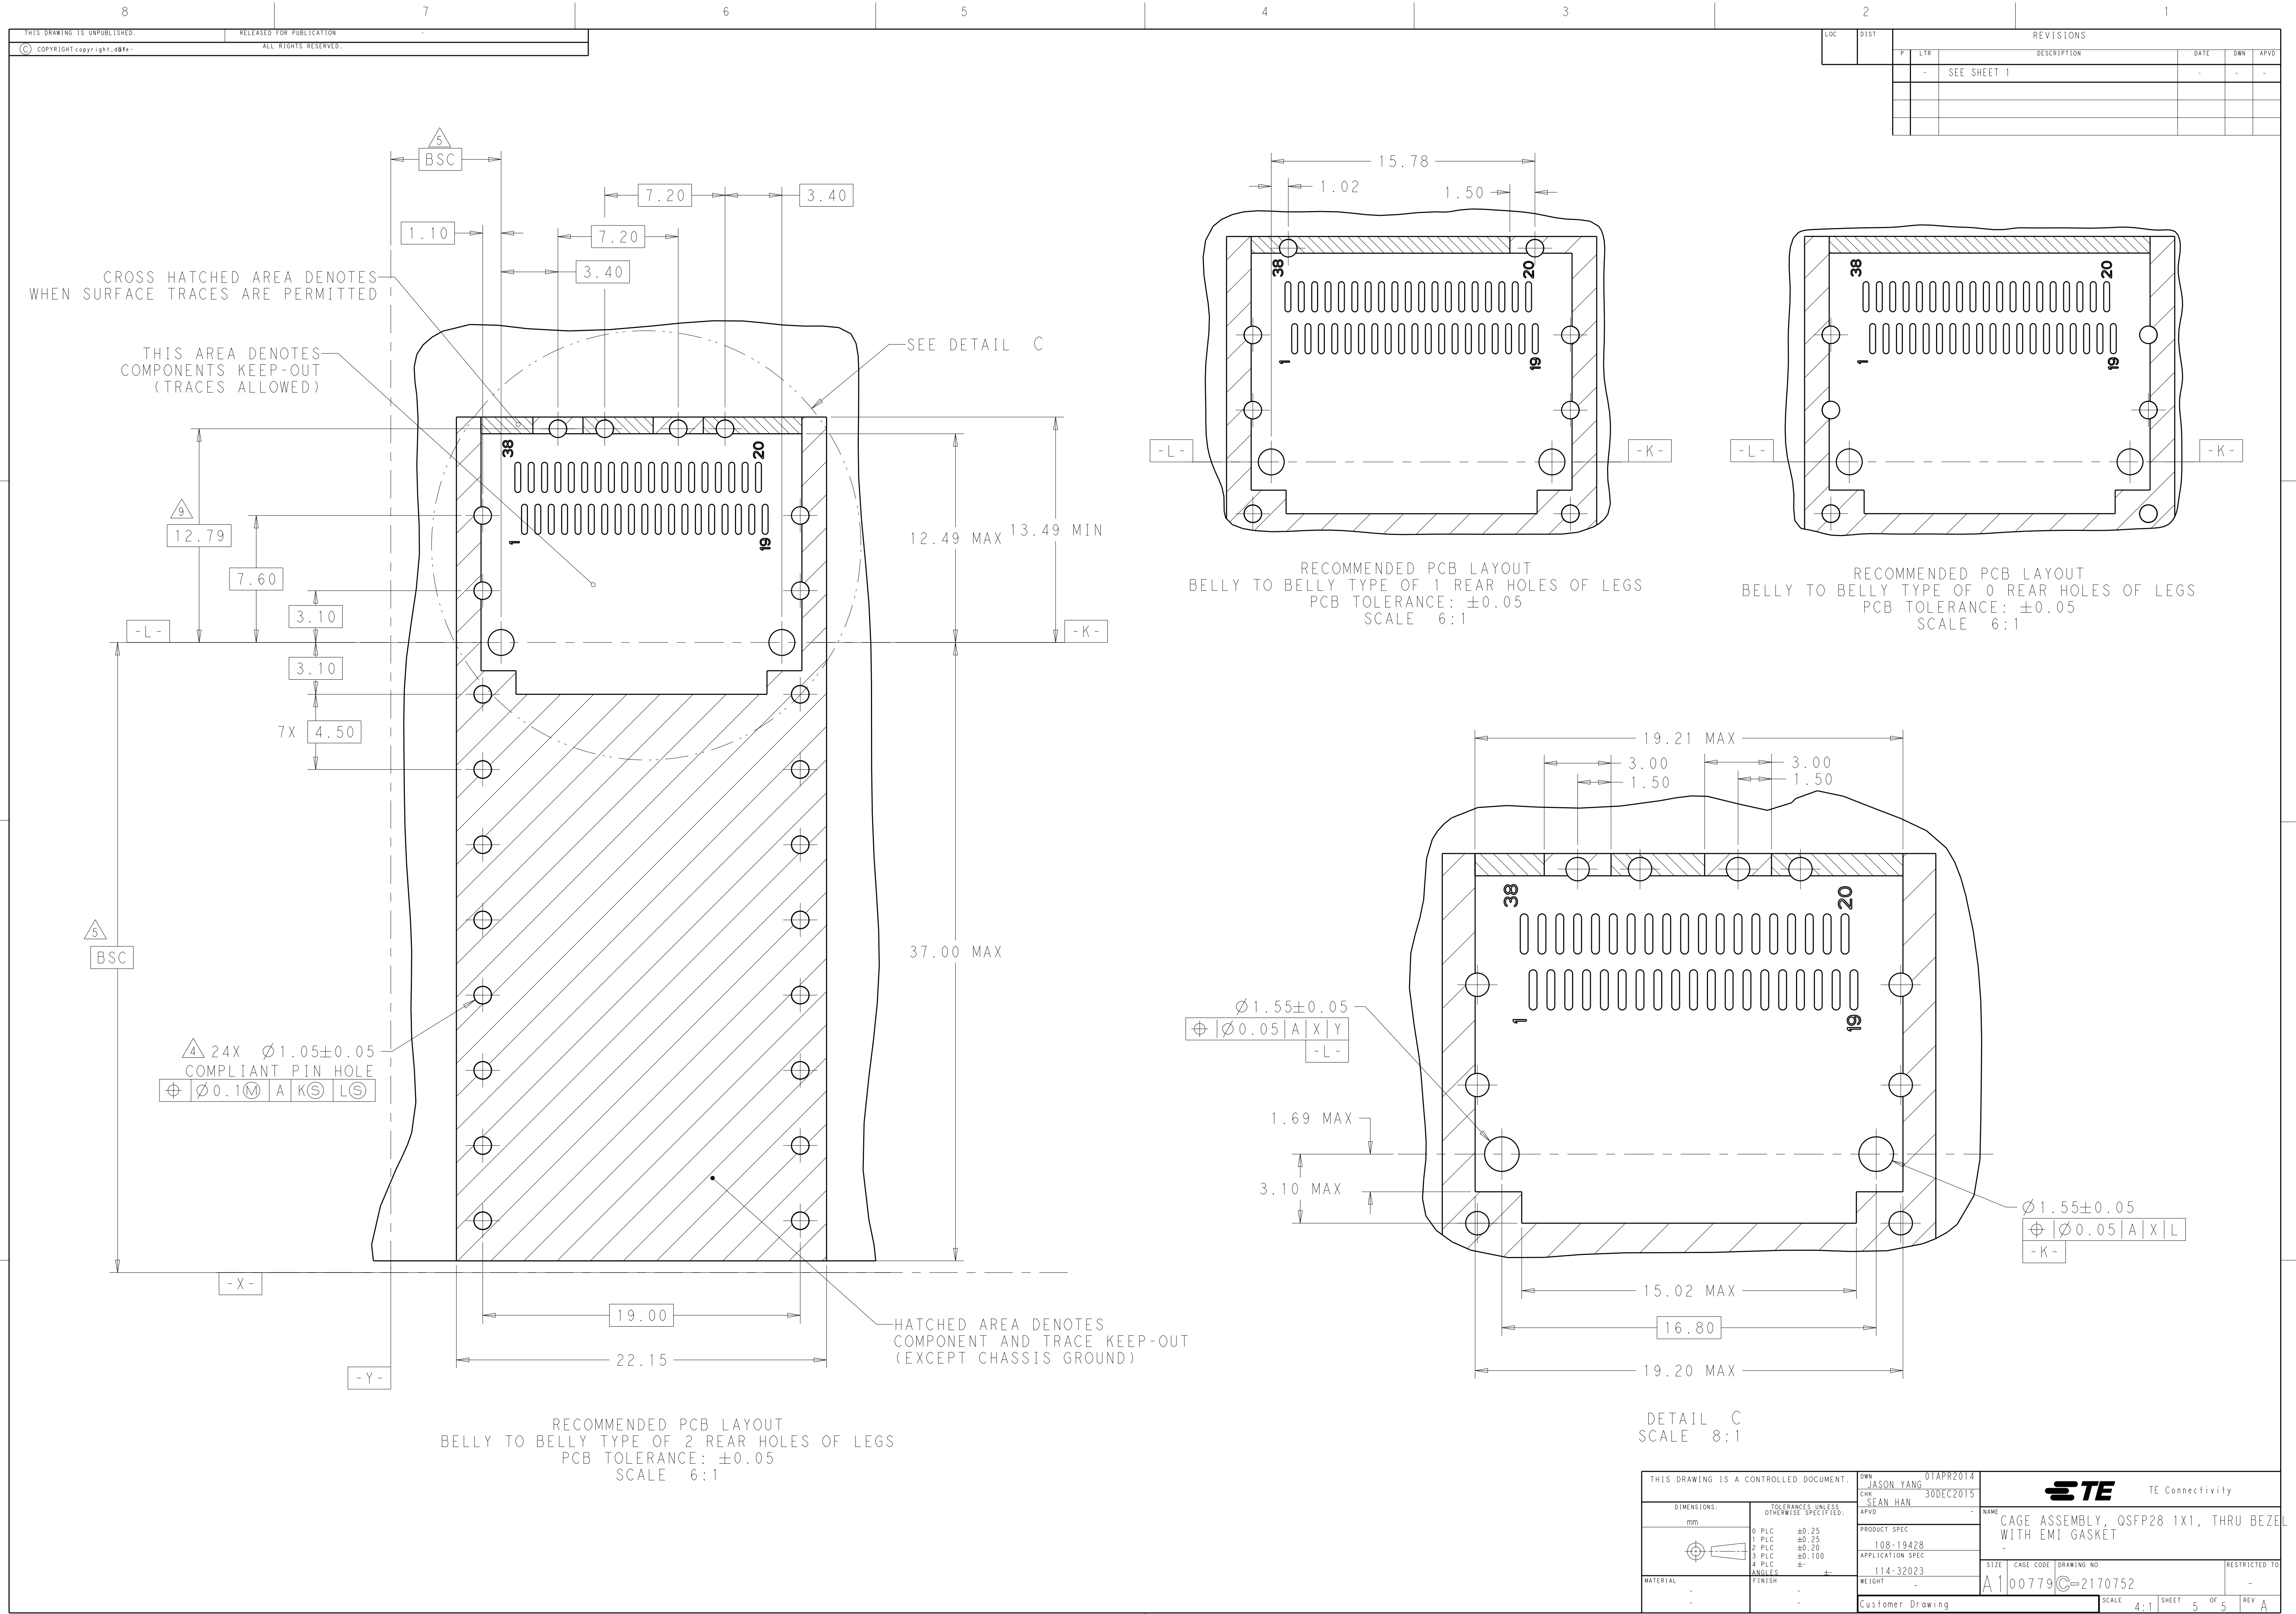

Компания «Life Electronics» занимается поставками электронных компонентов импортного и отечественного производства от производителей и со складов крупных дистрибьюторов Европы, Америки и Азии.

С конца 2013 года компания активно расширяет линейку поставок компонентов по направлению коаксиальный кабель, кварцевые генераторы и конденсаторы (керамические, пленочные, электролитические), за счёт заключения дистрибьюторских договоров

Мы предлагаем:

- Конкурентоспособные цены и скидки постоянным клиентам.
- Специальные условия для постоянных клиентов.
- Подбор аналогов.
- Поставку компонентов в любых объемах, удовлетворяющих вашим потребностям.
- Приемлемые сроки поставки, возможна ускоренная поставка.
- Доставку товара в любую точку России и стран СНГ.
- Комплексную поставку.
- Работу по проектам и поставку образцов.
- Формирование склада под заказчика.
- Сертификаты соответствия на поставляемую продукцию (по желанию клиента).
- Тестирование поставляемой продукции.
- Поставку компонентов, требующих военную и космическую приемку.
- Входной контроль качества.
- Наличие сертификата ISO.

В составе нашей компании организован Конструкторский отдел, призванный помогать разработчикам, и инженерам.

Конструкторский отдел помогает осуществить:

- Регистрацию проекта у производителя компонентов.
- Техническую поддержку проекта.
- Защиту от снятия компонента с производства.
- Оценку стоимости проекта по компонентам.
- Изготовление тестовой платы монтаж и пусконаладочные работы.



Тел: +7 (812) 336 43 04 (многоканальный)

Email: org@lifeelectronics.ru

www.lifeelectronics.ru